

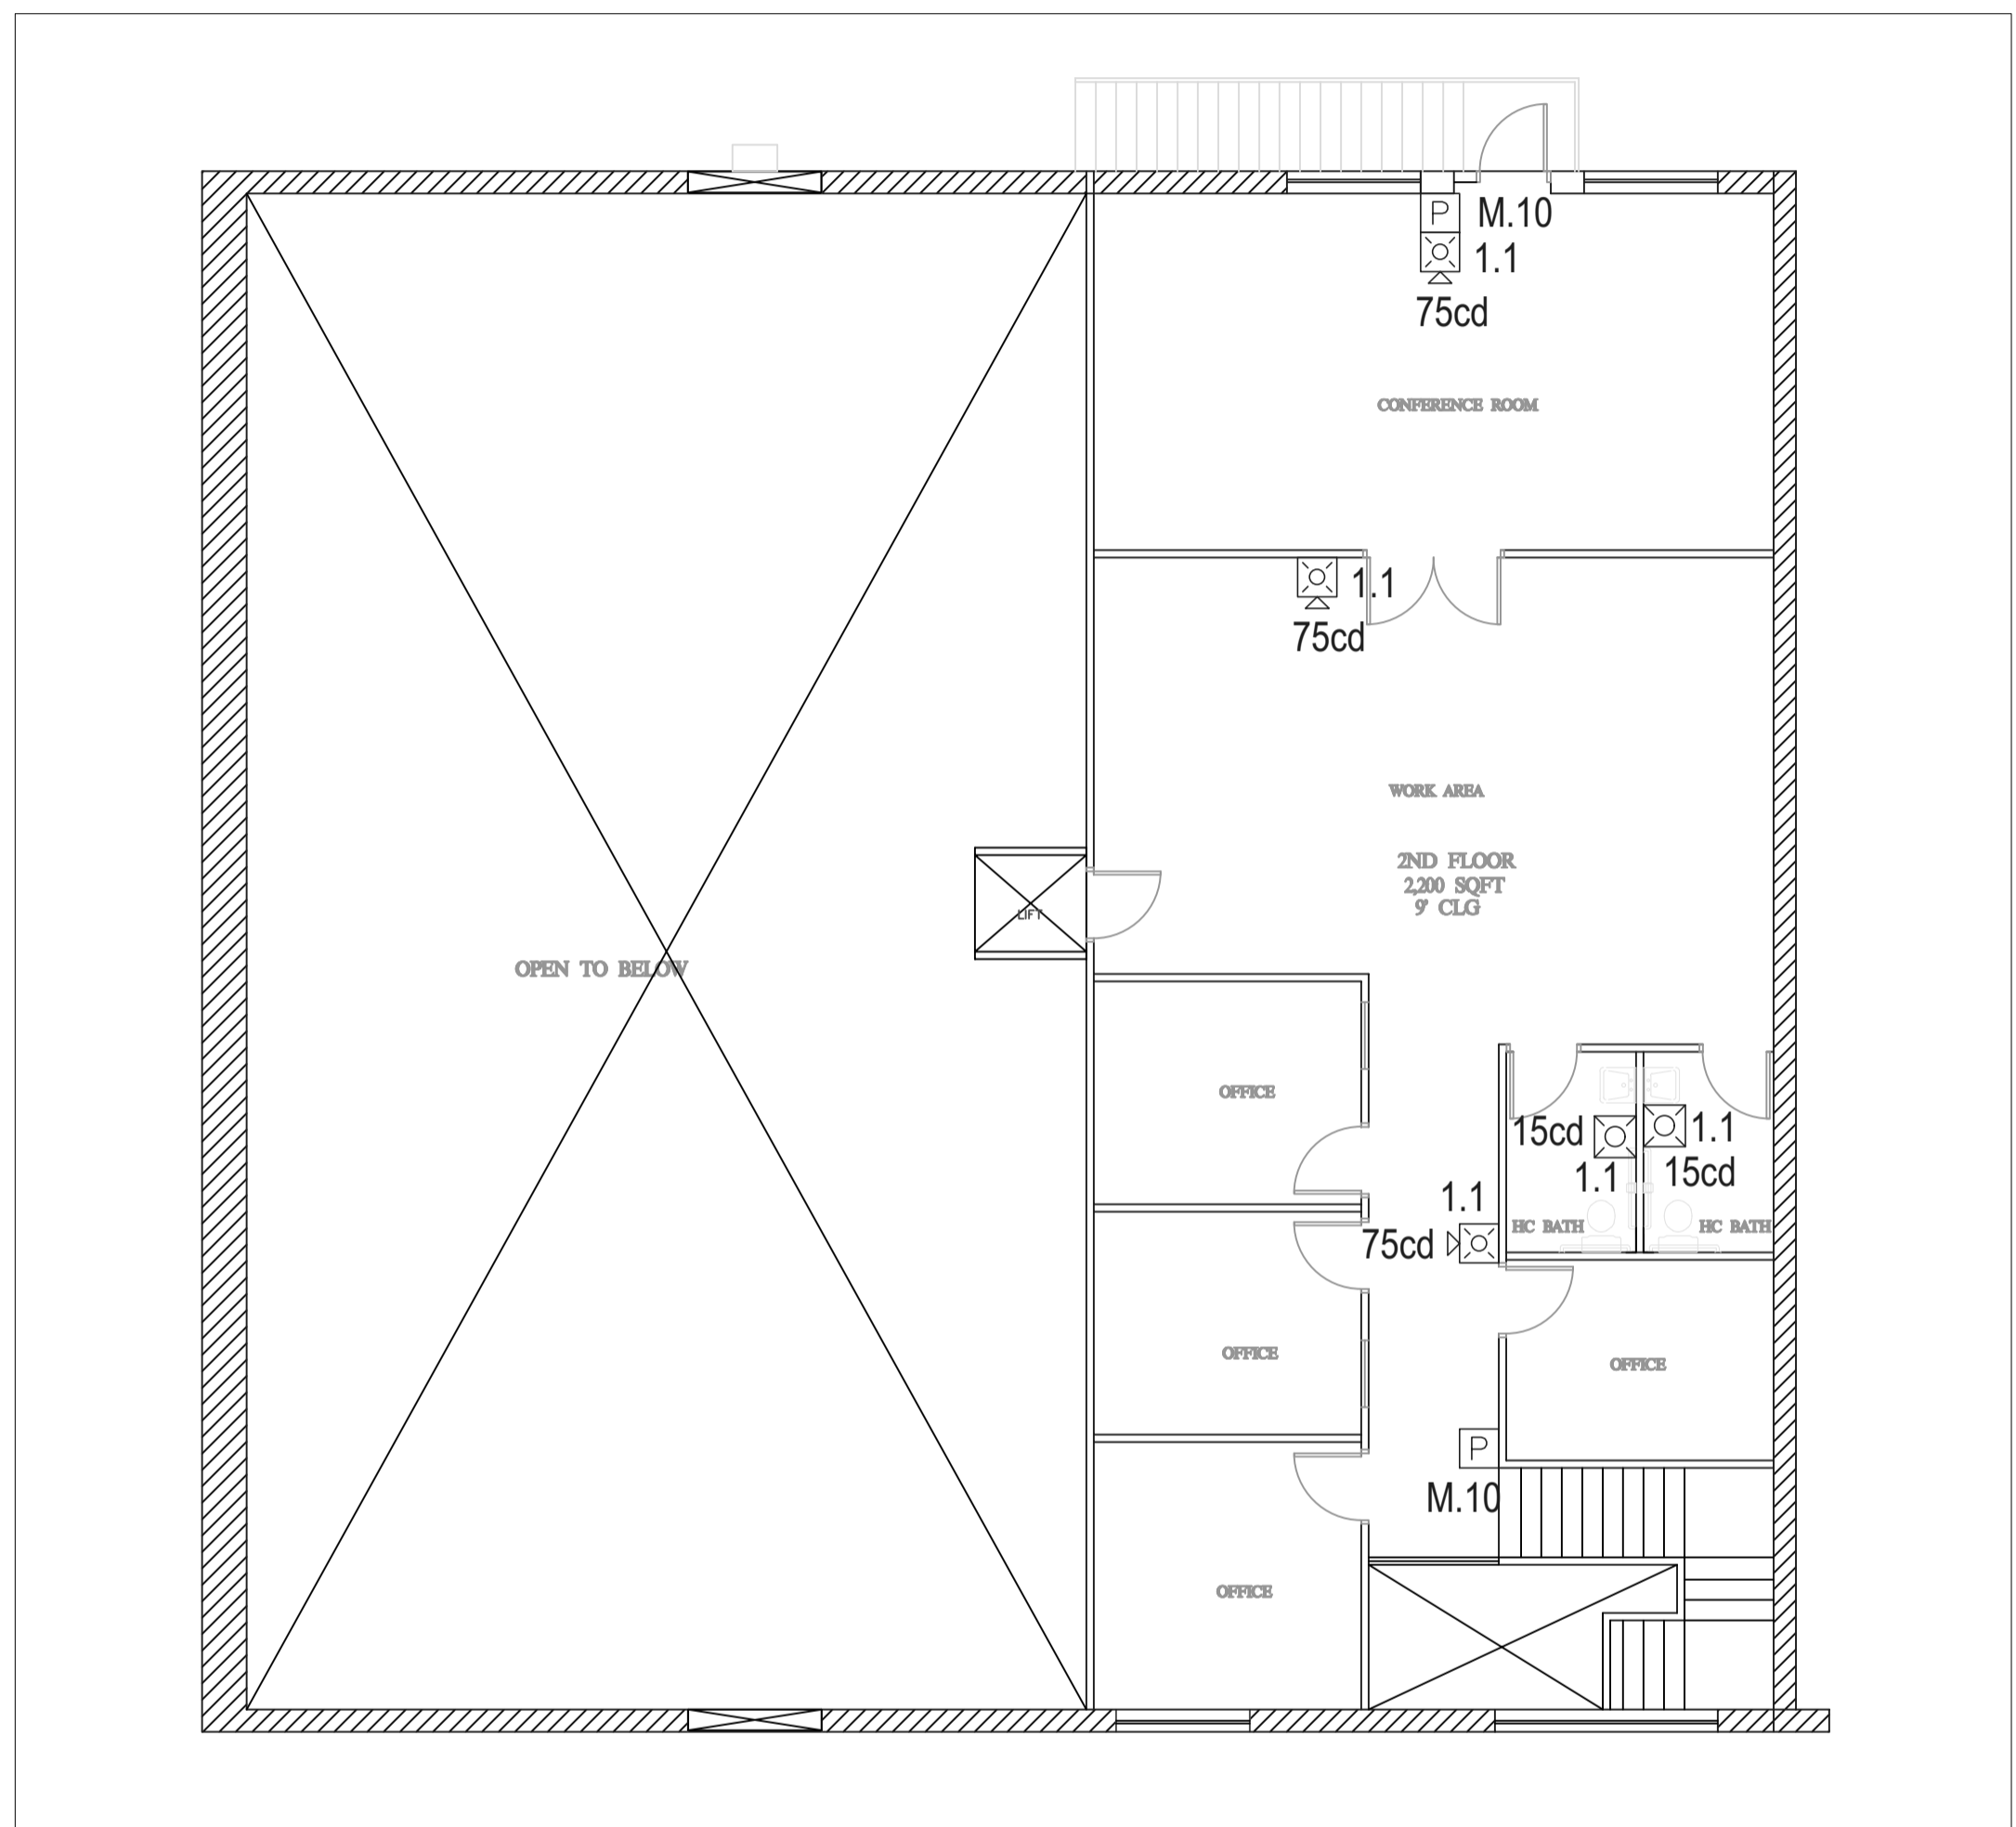


FIRST FLOOR FIRE ALARM FLOOR PLAN

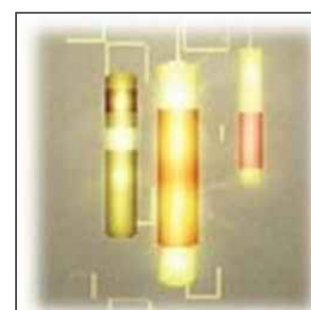

MEZZANINE FIRE ALARM FLOOR PLAN

Jorge J Salgado
 This item has been electronically signed and sealed by Jorge J. Salgado, P.E. using a Digital Signature. Printed copies of this document are not considered signed and sealed and the SHA authentication code must be verified on any electronic copies.
 11-03-2021
 2023.04.04 15:55:55 -04'00'

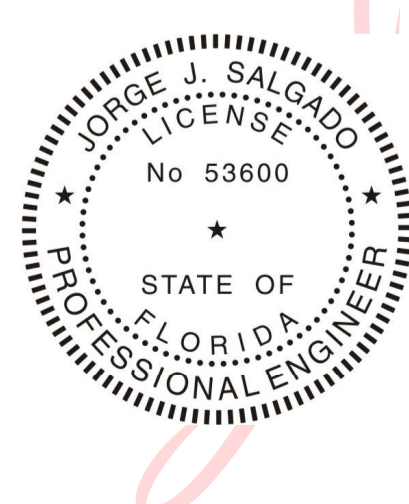

JJ CONSULTING GROUP, INC.
 CA LICENSE #31838
 JORGE J. SALGADO, P.E. #53600
 2001 TIZEWELL CIRCLE
 #1509
 ORLANDO, FL 32837



life safety
 SINGLE SOURCE SOLUTION
 FIRE ALARM • SPRINKLER • SECURITY
 4707 140th N SUITE 108 CLEARWATER, FL 33762

NO.	DATE	REVISION DESCRIPTION	BY
0	04/04/23	EOR SUBMITTAL	AW

REVISION	SYSTEM NUMBER	PERMIT JOB NUMBER	DRAWING NUMBER
0	SYSTEM #1	162204936	FA-1 OF 2

BELASCO OFFICE AND WAREHOUSE
 6824 BELASCO AVE. ORLANDO, FL 32814
 FIRE ALARM FLOOR PLAN AND RISER DIAGRAM
 Approved Plans
 Division of Building Safety

This Approval does not grant permission to violate any applicable code. Encroachment of any part of this improvement can result in a cloud on the title of this property. Keep this plan on the job site at all times.