


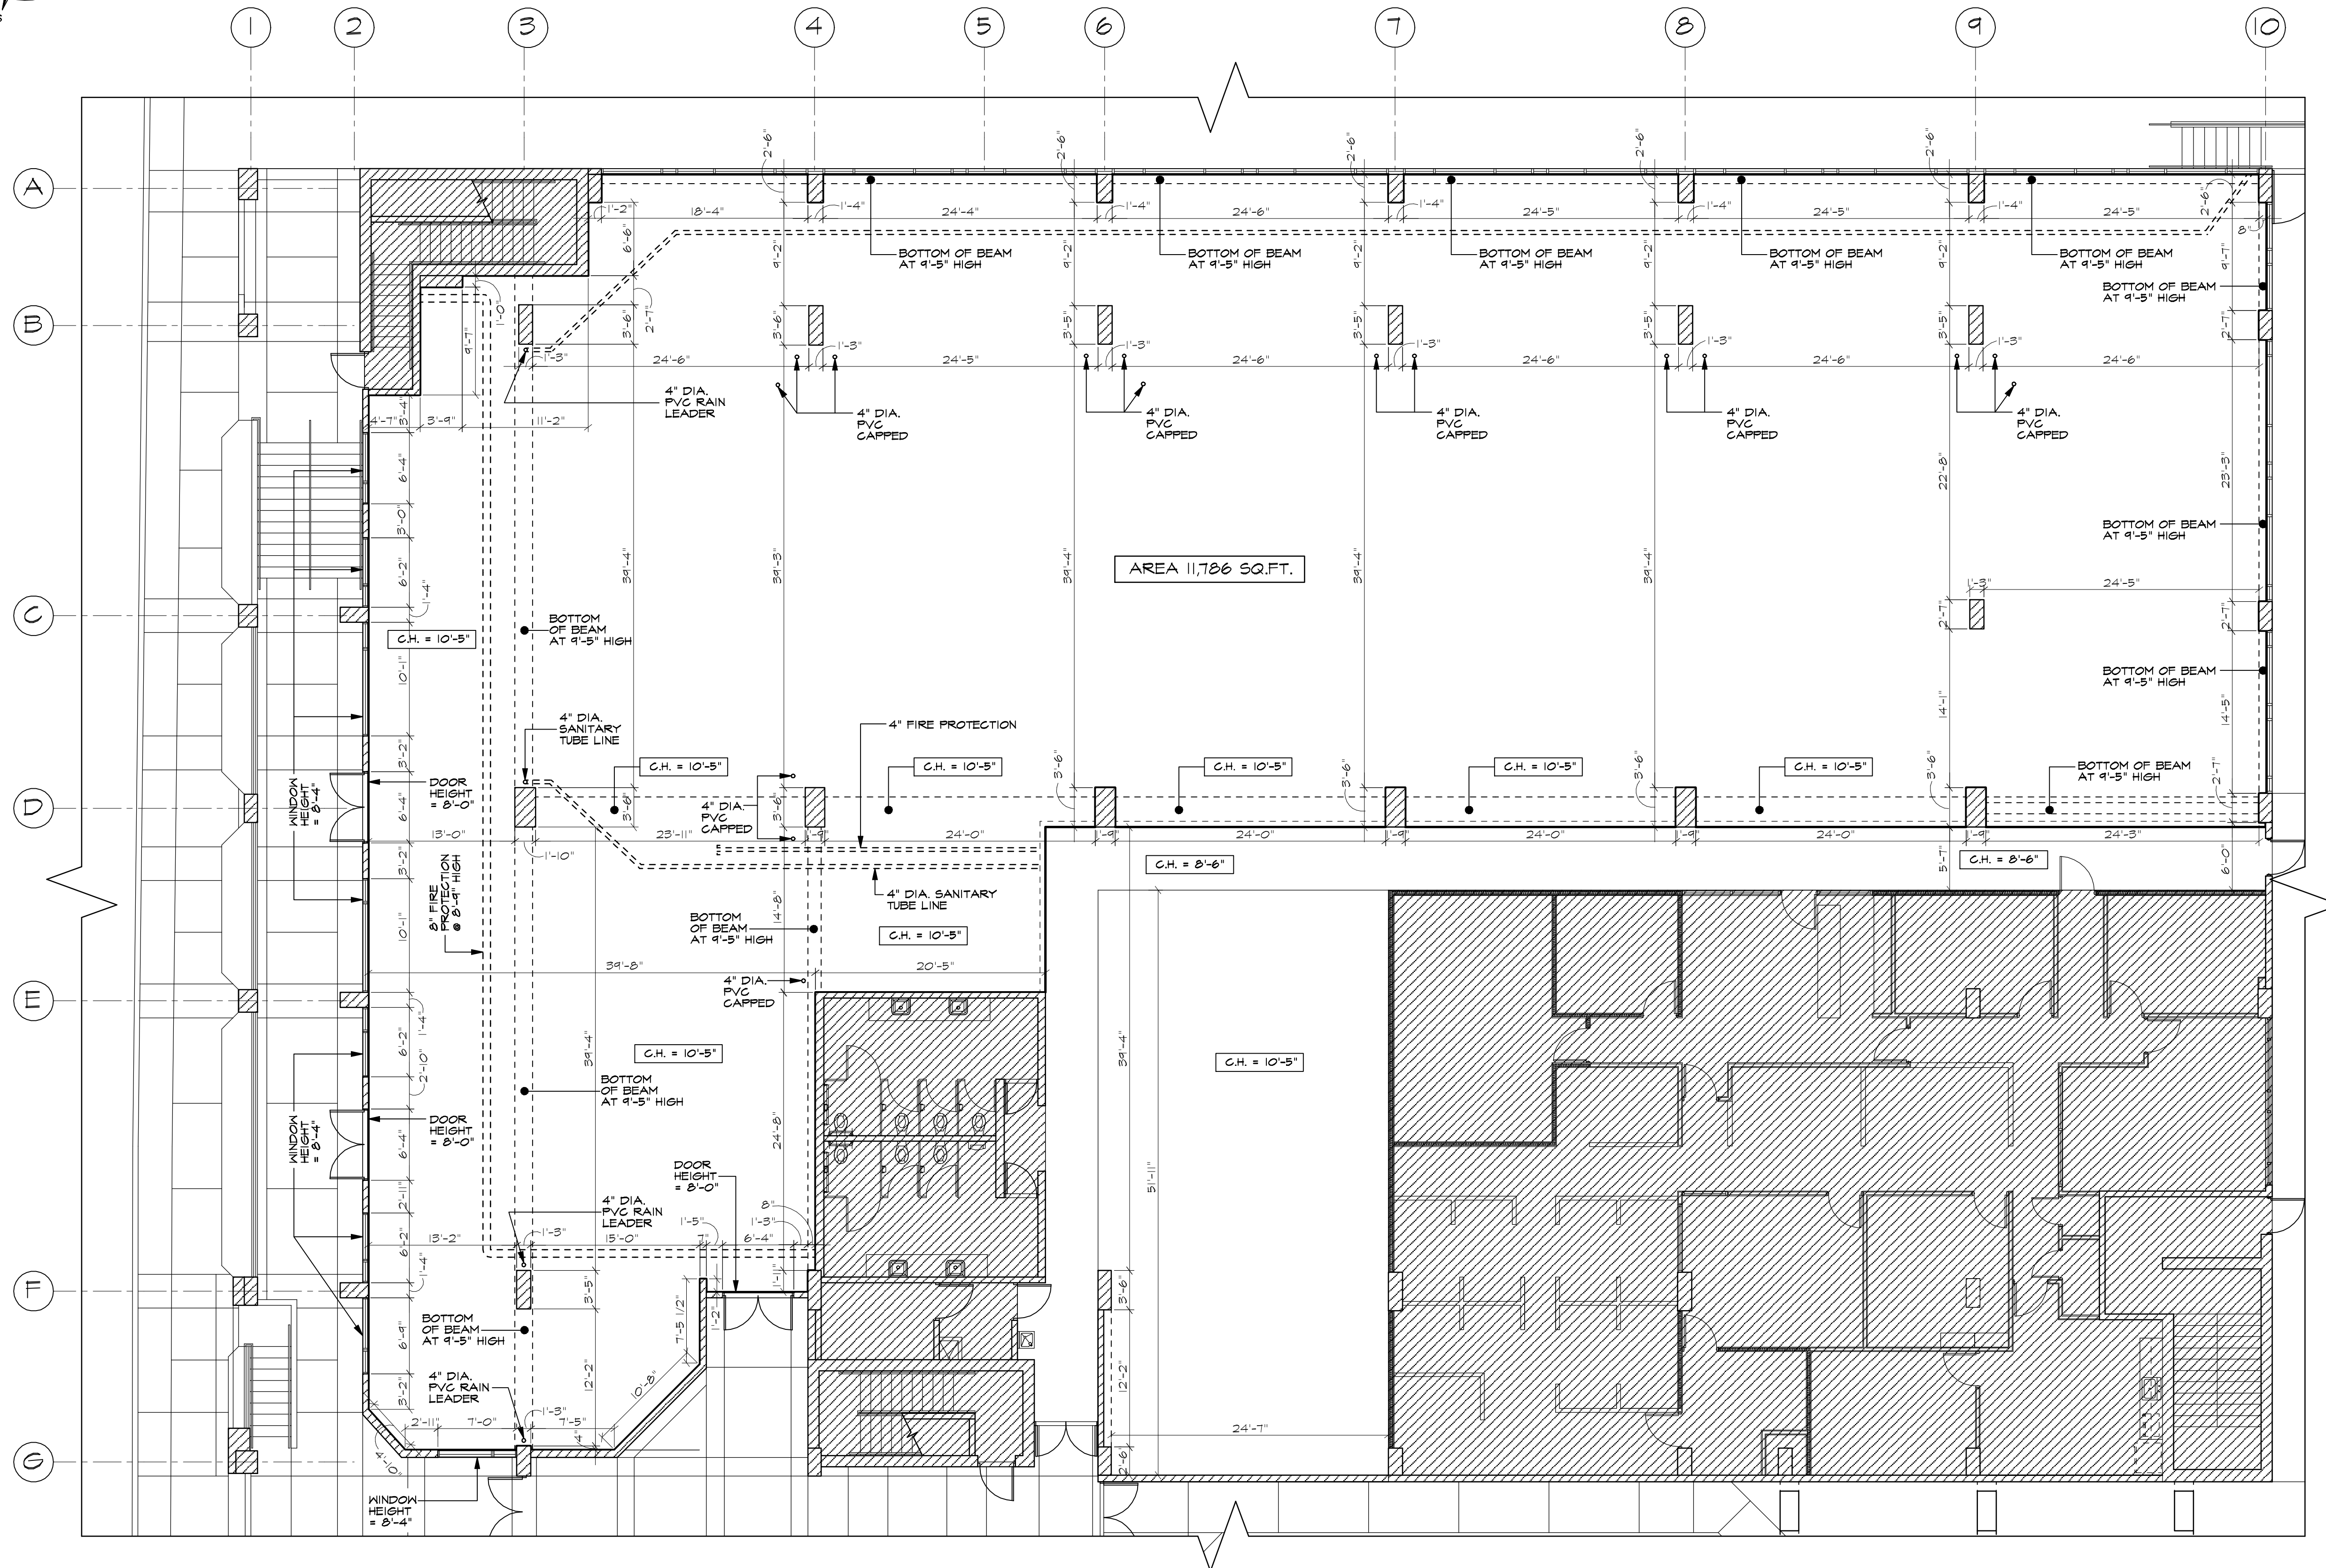

A. C. C. ARCHITECTS, P. S. C.

PMB SUITE 412
90 AVE. RIO HONDO
BAYAMON, P.R.
00961-3113

27 CALLE MAYAGÜEZ
URB. PEREZ MORRIS
HATO REY, P.R.
00917

TEL. (787) 759-1044

FAX: (787) 759-8017

e-mail : acc_psc@yahoo.com

METROPOLIS
FIRST FLOOR

AVE. JUAN PONCE DE LEON
SAN JUAN, PUERTO RICO

AS-BUILT FLOOR PLAN
SCALE: 1/8"=1'-0"

IMPORTANT NOTE FOR CONTRACTOR


CONTRACTOR SHALL VERIFY ALL DIMENSIONS AND SITE CONDITIONS BEFORE PROCEEDING WITH WORK. IF ANY DISCREPANCIES, ERRORS OR OMISSIONS SHOULD BE ENCOUNTERED AT ANY TIME, CONTRACTOR SHALL IMMEDIATELY NOTIFY ARCHITECT BY E-MAIL. IF ARCHITECT STARTED SO THAT PROPER CORRECTIONS ARE MADE, ARCHITECT IS NOT NOTIFIED PRIOR TO COMPLETION OF THE WORK, THE CONTRACTOR SHALL BE RESPONSIBLE FOR ANY RESULTANT DISCREPANCIES, ERRORS AND/OR OMISSIONS.

ALL SECTIONS AND DRAWINGS HEREIN ARE PRINTED ISSUED BY THE ARCHITECT. THE PROPERTY OF THE ARCHITECT AND SHALL NOT BE REUSED ON ANY OTHER LOCATION (EXCEPT THE ONE FOR WHICH THE MODEL EXPRESSLY DESIGNED).

IF THESE DRAWINGS OR ANY/THE PART THEREOF IS REPRODUCED WITH ANY ALTERATION, THE CONTRACTOR SHALL BE RESPONSIBLE AND WILL BE INDEBTED TO THE ARCHITECT FOR HIS FULL COMMISSION.

CONTRACTOR SHALL NOT USE FOR CONSTRUCTION PURPOSES ANY DRAWINGS THAT WERE AWARDED FOR INFORMATION TO THE SHOW OF ARCHITECT. ALL PLANS BEING USED BY CONTRACTOR SHOULD BE IDENTIFIED WITH THE LABEL "FOR CONSTRUCTION ONLY" SHOWN BY ARCHITECT.

LEGEND

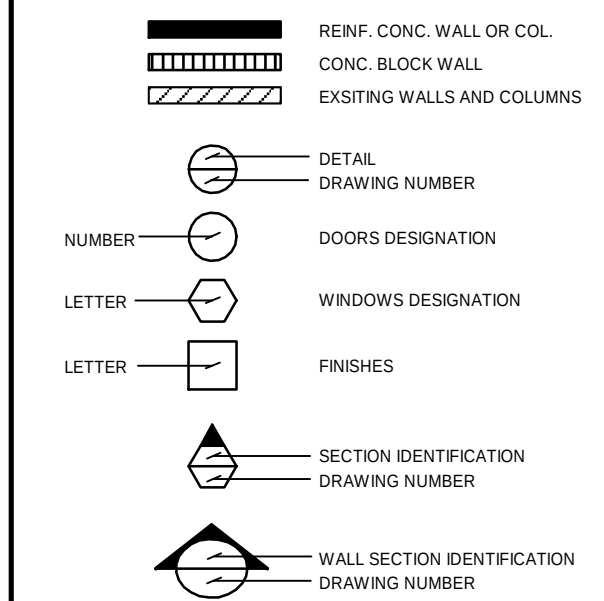

Consultants :

Site :	N/A
Structural	N/A
Plumbing	
...	
Mech. A/C	N/A
Electrical :	
...	

Project No. : PROP.	Plot Date : DEC-4-14	Drawn By : FSJ	File Name : AS-01
------------------------	-------------------------	-------------------	----------------------

[illegible]

CONSTRUCTION DRAWING REVISIONS

Dwg. History:

AS-1

Sheet	1	Of	1
-------	---	----	---