

STRUCTURAL NOTE:

SEE STRUCTURAL DRAWINGS FOR ADDITIONAL INFORMATION, DETAILS, NOTES, ETC.

M.E.P. NOTE:

SEE M.E.P. DRAWINGS FOR ADDITIONAL INFORMATION, DETAILS, NOTES, ETC.


NOTE: LIGHT LOCATIONS NOT TO BE DETERMINED BY ELECTRICAL CONTRACTOR

NOTE: INDICATE ALL LOW VOLTAGE INCLUDING BUT NOT LIMITED TO REFRIGERATORS, FREEZERS, ETC. BY OWNER PRIOR TO THE START OF CONSTRUCTION

NOTE: ELECTRICAL DRAWINGS FOR FIRE EXTINGUISHERS AND LIGHTING SIGNS

REFLECTED CEILING LEGEND:

-
-
-
-
-

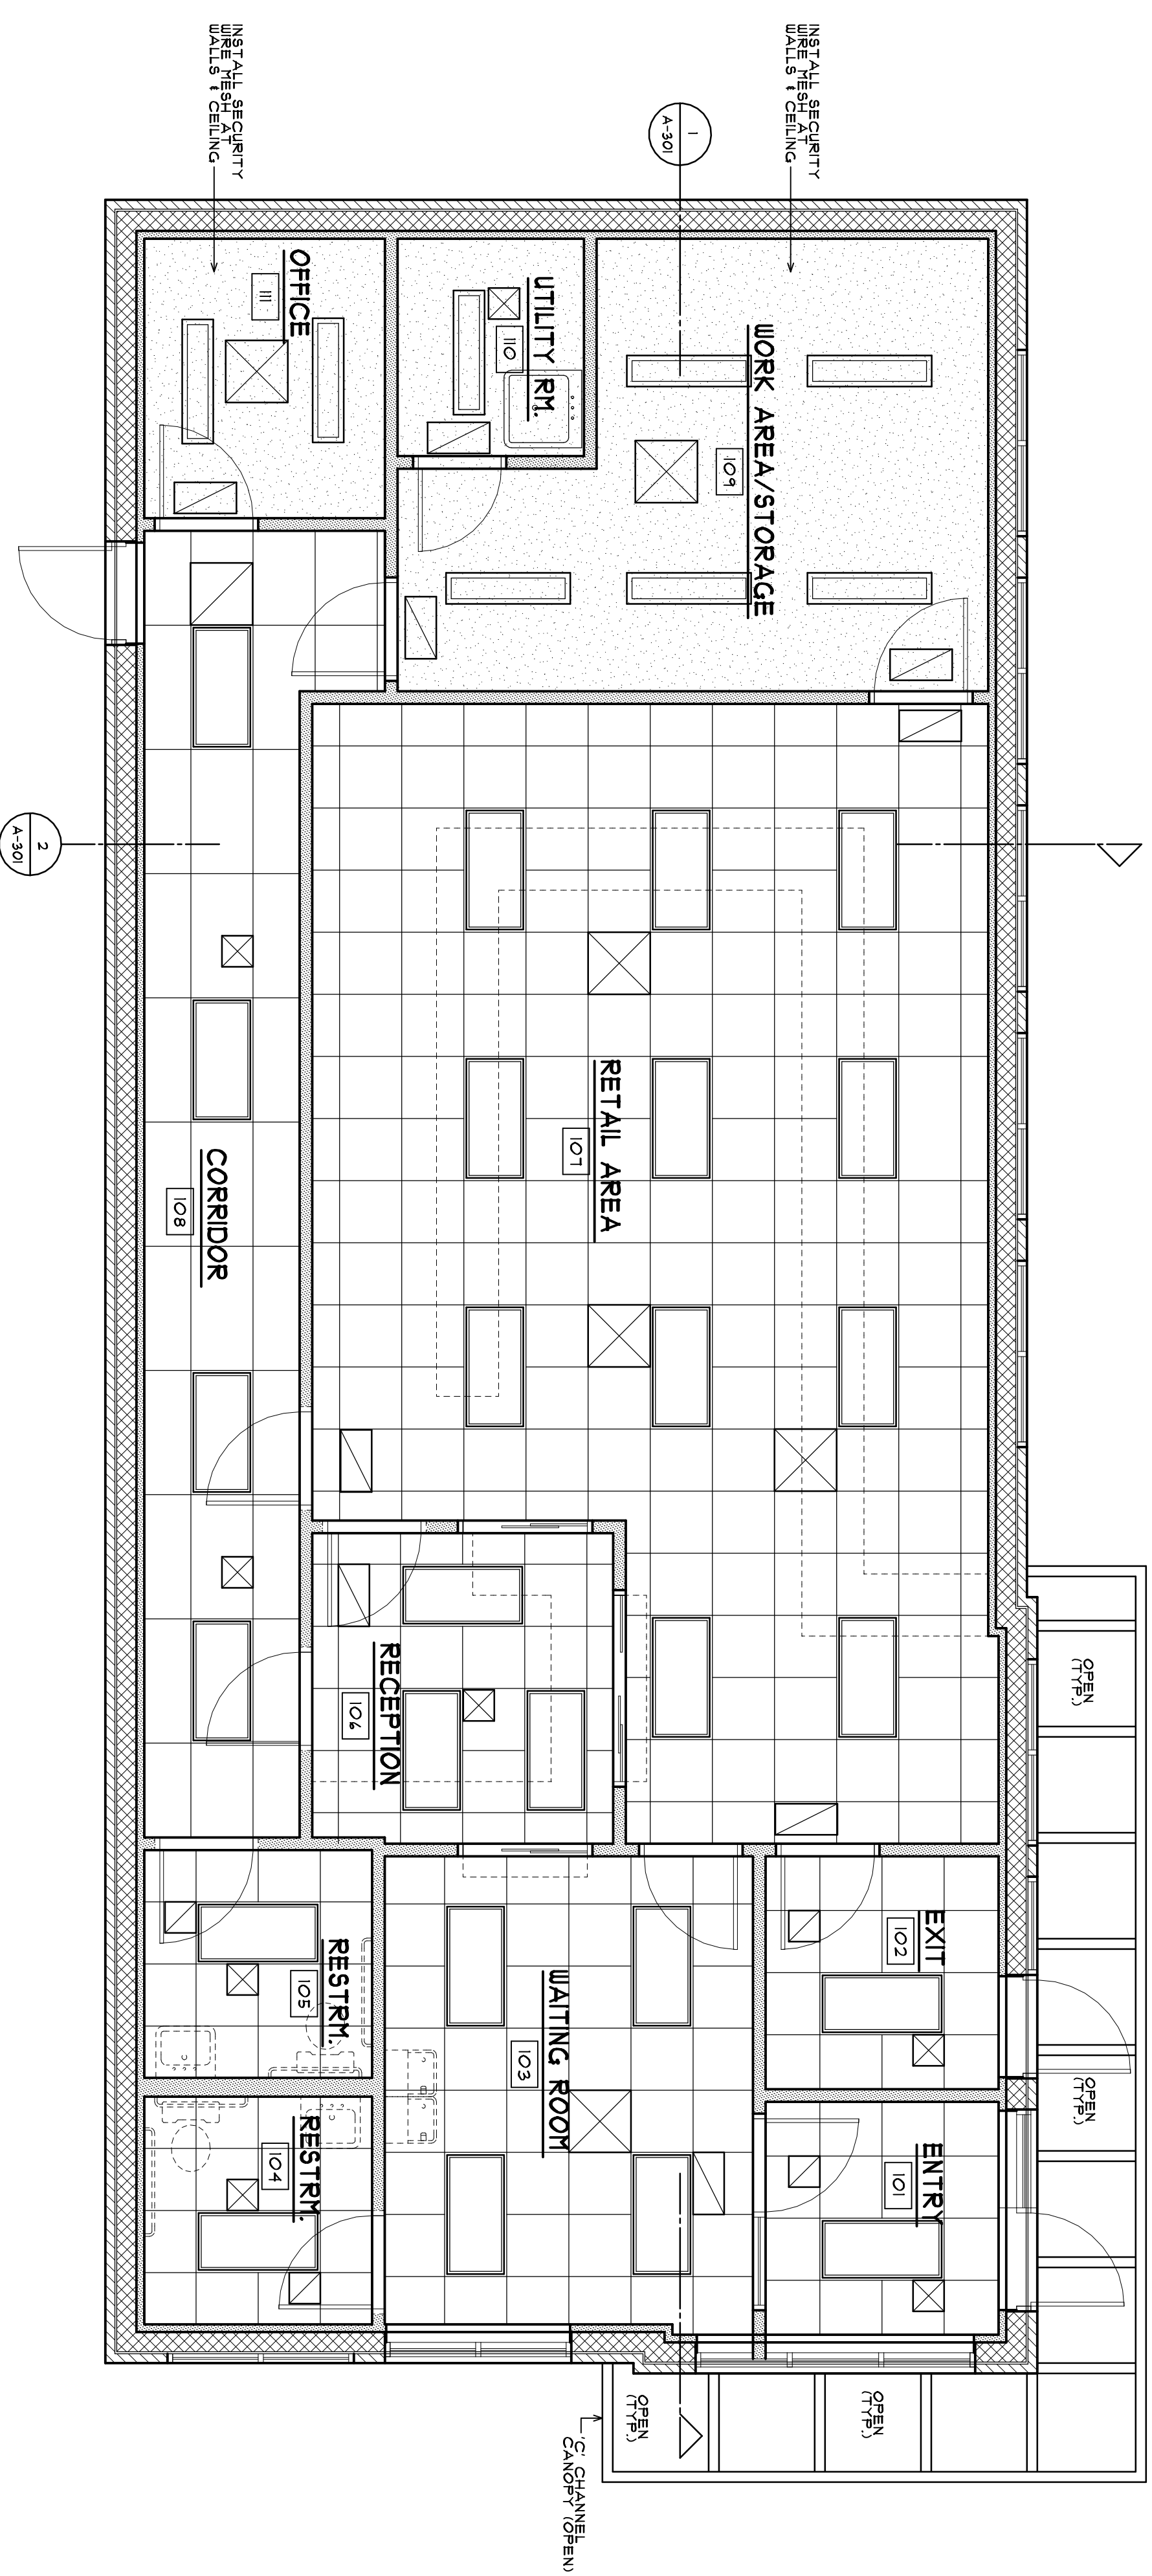

1 REFLECTED CEILING PLAN

SCALE: 1/4" = 1'-0"

