


THESE DRAWINGS AND DETAILS ARE BY THEIR NATURE SCHEMATIC AND DO NOT DEPICT EVERY CONDITION, DETAIL, CONNECTION, ETC. WHICH WILL OCCUR.

KNOWLEDGEABLE, PROPERLY LICENSED CONTRACTORS AND SUB-CONTRACTORS MUST BE RELIED UPON TO ACHIEVE PROPER INSTALLATION OF MATERIALS, FLASHING, WEATHER SEALING, MATERIAL TRANSITIONS, SEPARATIONS, CONNECTIONS, ANCHORAGE, ETC.

VERIFY ALL GIVEN DIMENSIONS IN THE FIELD.

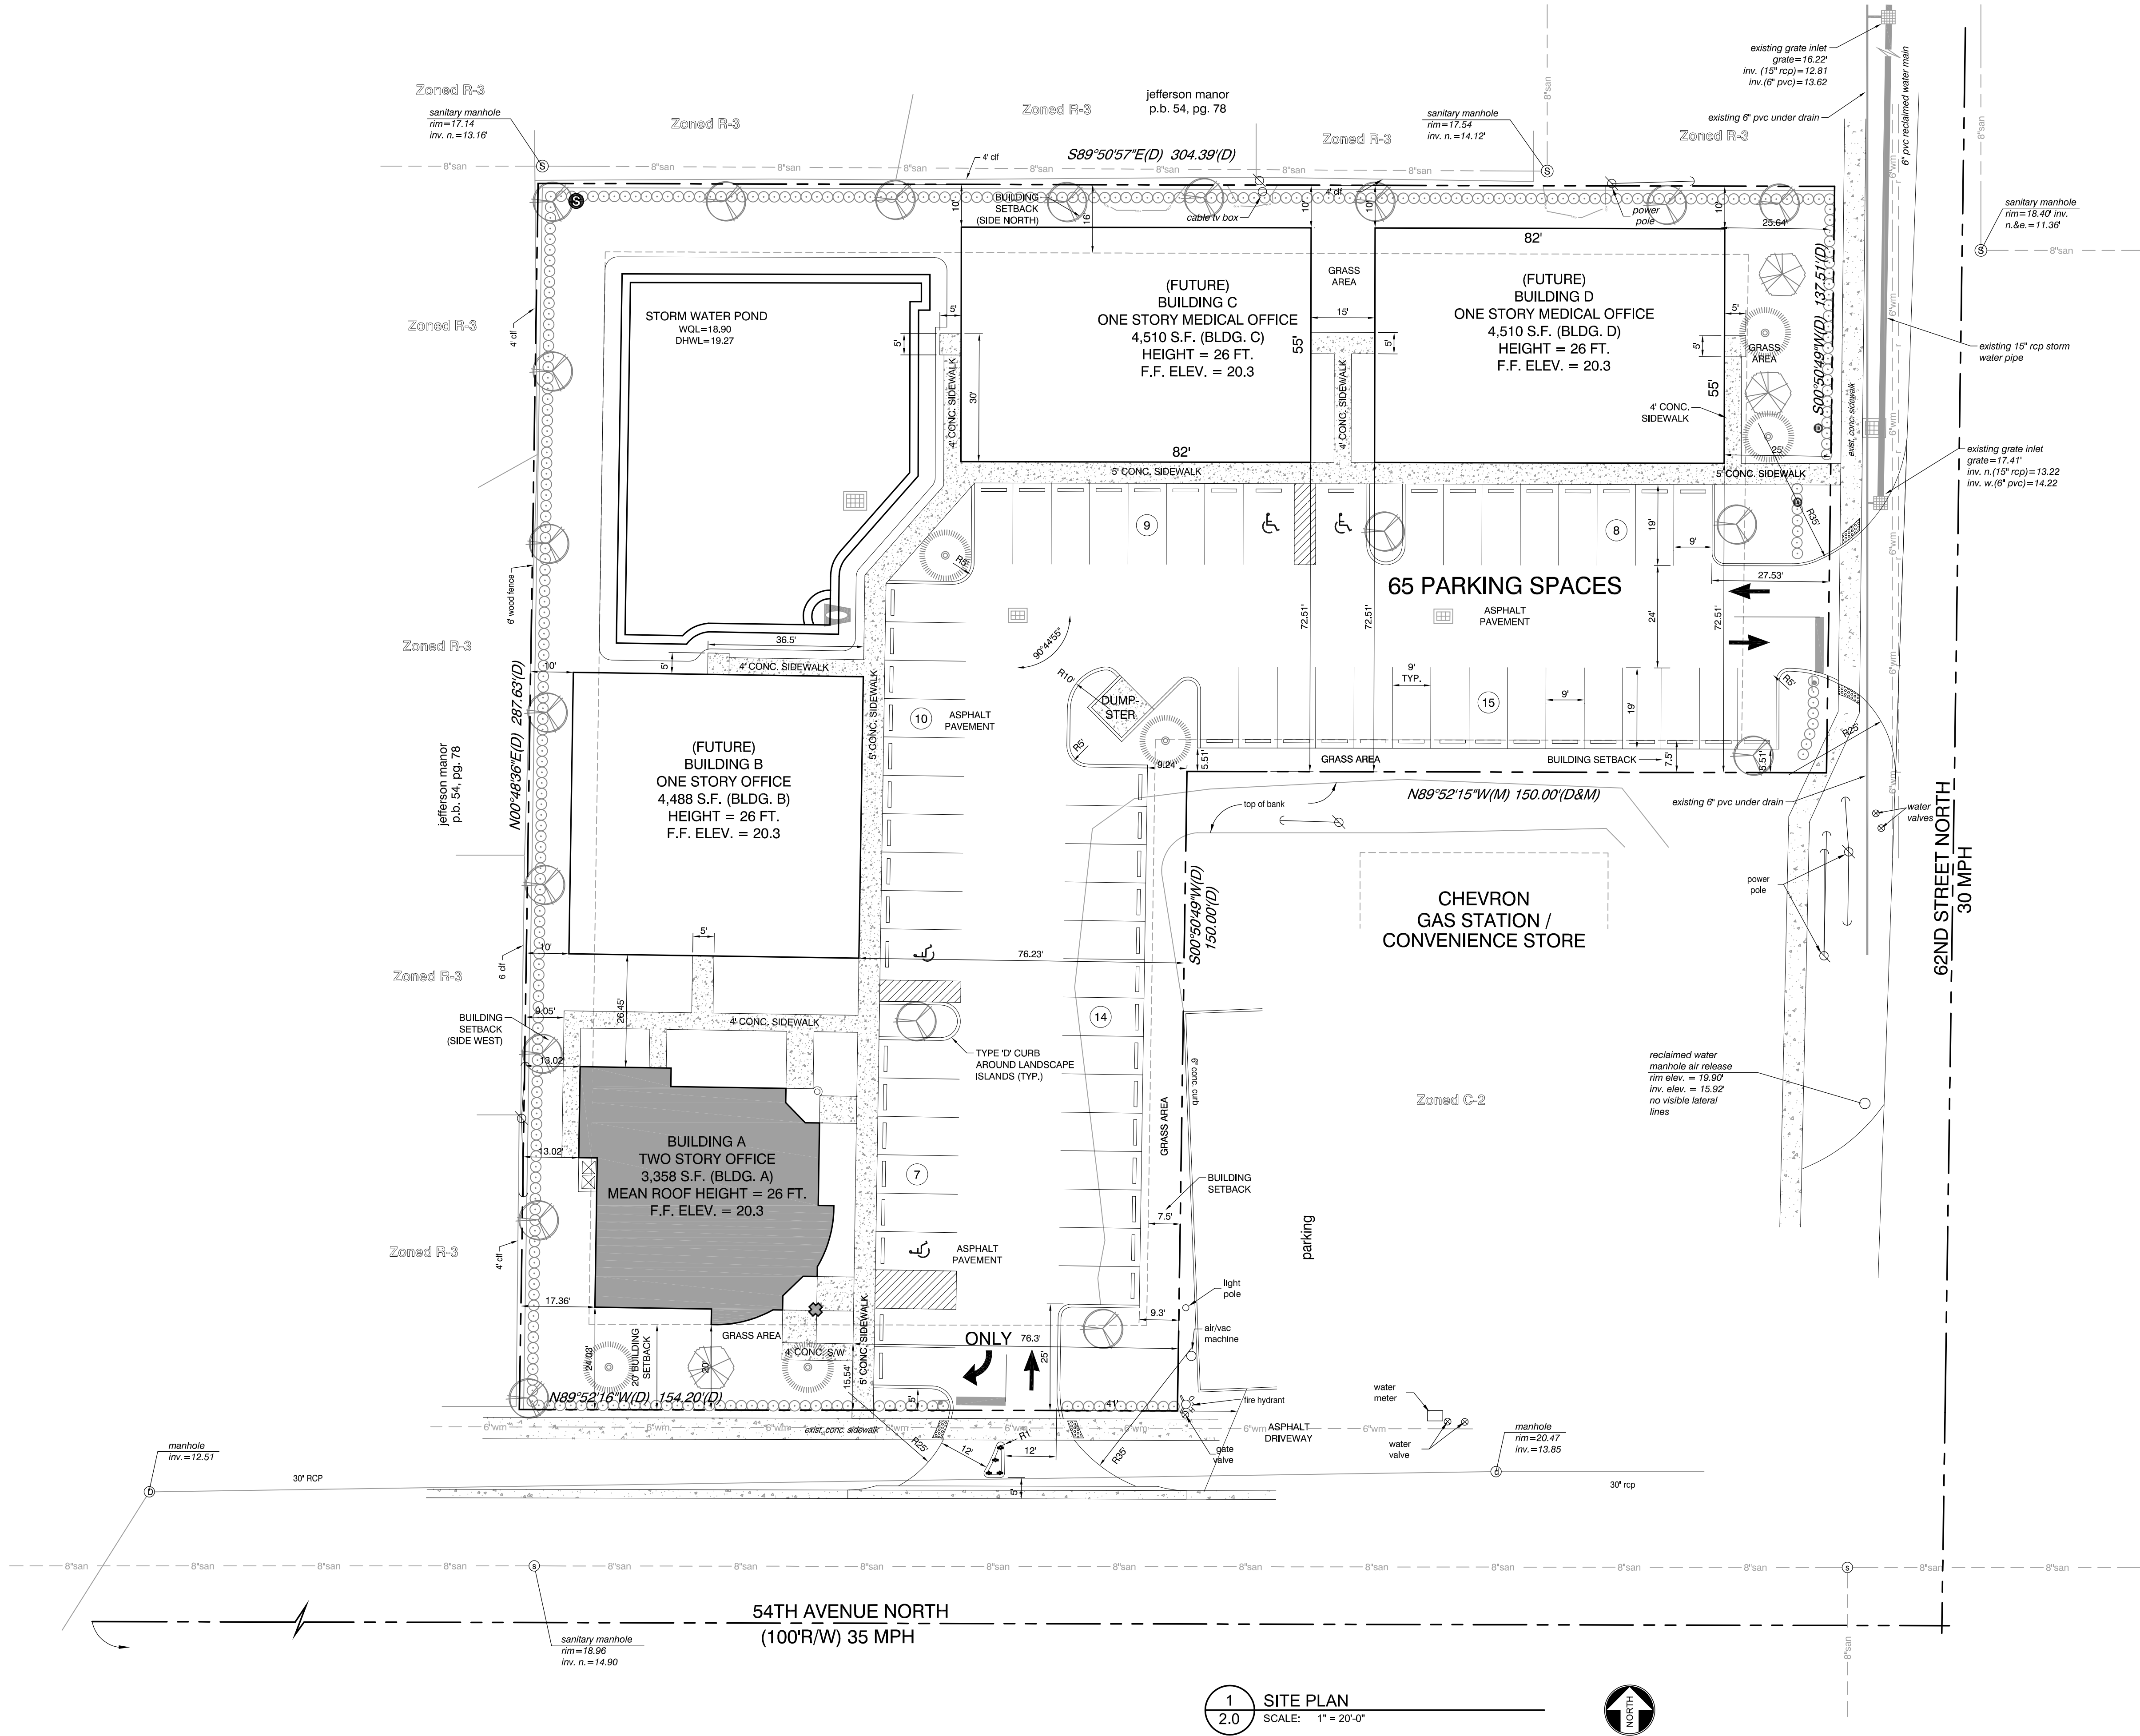

Drafting Provided By:
CONTRACT CAD SERVICES, INC.
3273 Harbor Lake Drive
Largo, Florida 33770-4277
ph. (727) 579-4498
e-mail info@contractcad.com
Deuteronomy 4:39 Know therefore today, and take it to your heart, that the Lord, He is God in heaven above and on the earth below, there is no other.

STRUCTURAL ENGINEER:
Dara Thomas, P.E.
118 Laurel Tree Way
Brandon, Florida 33511
phone (727) 455-1156
FL. REG.# 40290

Dara Thomas, P.E.
REG. #40290

CONTRACTOR:

CLIENT:
**HIRSCHFIELD
MEDICAL OFFICE**
Kenneth City, Florida
PARCEL# 32-3016-69930-332-0401

MARK	DATE	DESCRIPTION

SCALE: AS NOTED
DRAFTING BY: J.L.L., B.L.L.
CHECKED BY: D.T.
JOB NUMBER: 2020-1652
ISSUE DATE: 2-5-2020

Site Plan
SHEET NO. SHEET 2 OF 16

2.0