


GARGON OFFICE
 FLORIDA
 COCA

BRIEL RHAME POYNTER & HOUSER
 ARCHITECTS ENGINEERS, INC.
 MELBOURNE - TALLAHASSEE, FLORIDA

NO.	DATE	REVISION	BY
1	9-1-52	GENERAL	L.S.



CIVIL LEGEND

SYMBOLS	DESCRIPTION
NEW	EXISTING
—○—	POWER LINE WITH POLE
—○—	UNDERGROUND ELECTRIC
—○—	TELEPHONE
—○—	CONTOURS
—○—	SPOT ELEVATION
—○—	SHALE OR FLOW DIRECTION
—○—	FENCE
—○—	PROPERTY LINE
—○—	RIGHT-OF-WAY LINE
—○—	CENTERLINE
—○—	BUILDING OR STRUCTURES
—○—	CONCRETE WALK/DRIVE
—○—	ASPHALT PAVEMENT
—○—	CURB
—○—	SANITARY SEWER CLEAN-OUT
—○—	STOP DRAIN
—○—	SLURV WITH HEADWALLS
—○—	TEE METER IN VOLT

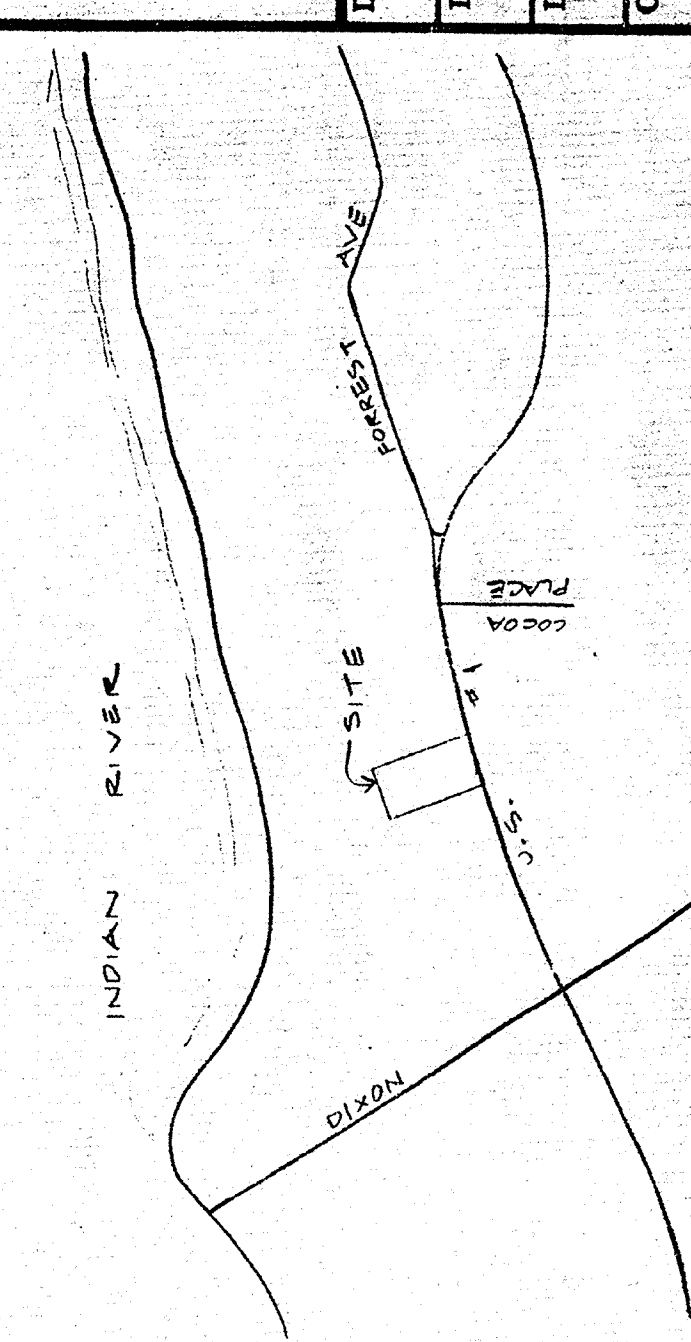



VICINITY MAP
 NO SCALE

FOUNDATION PLAN

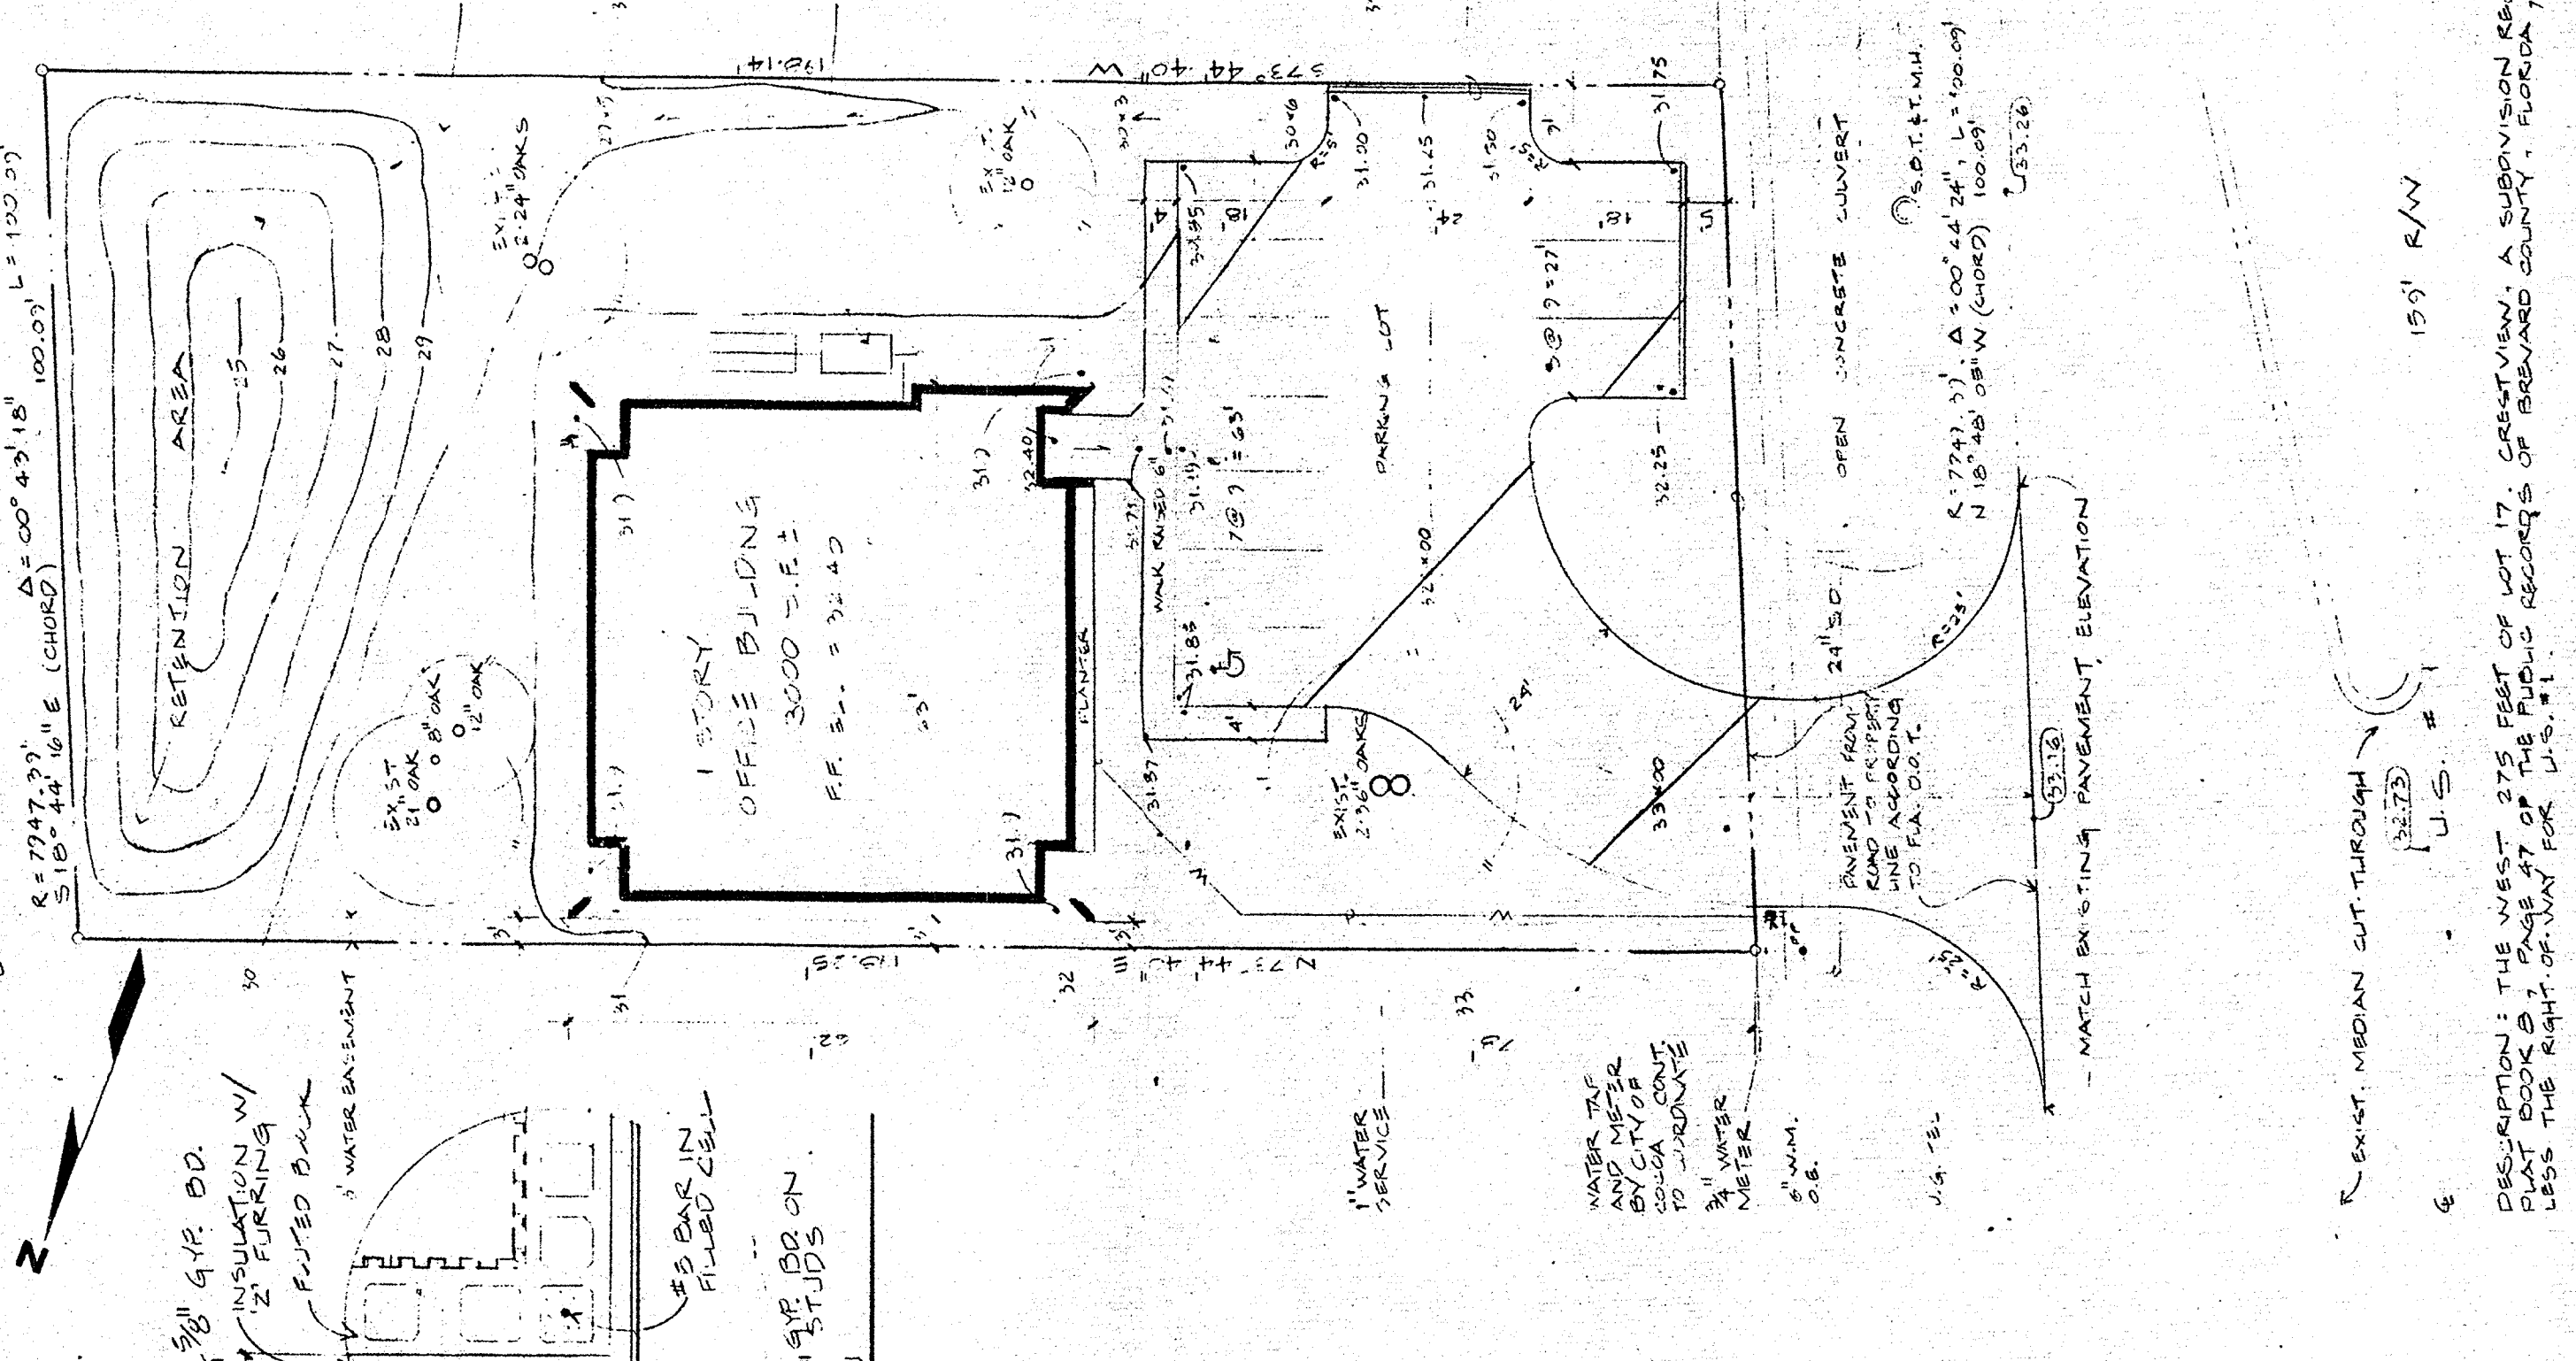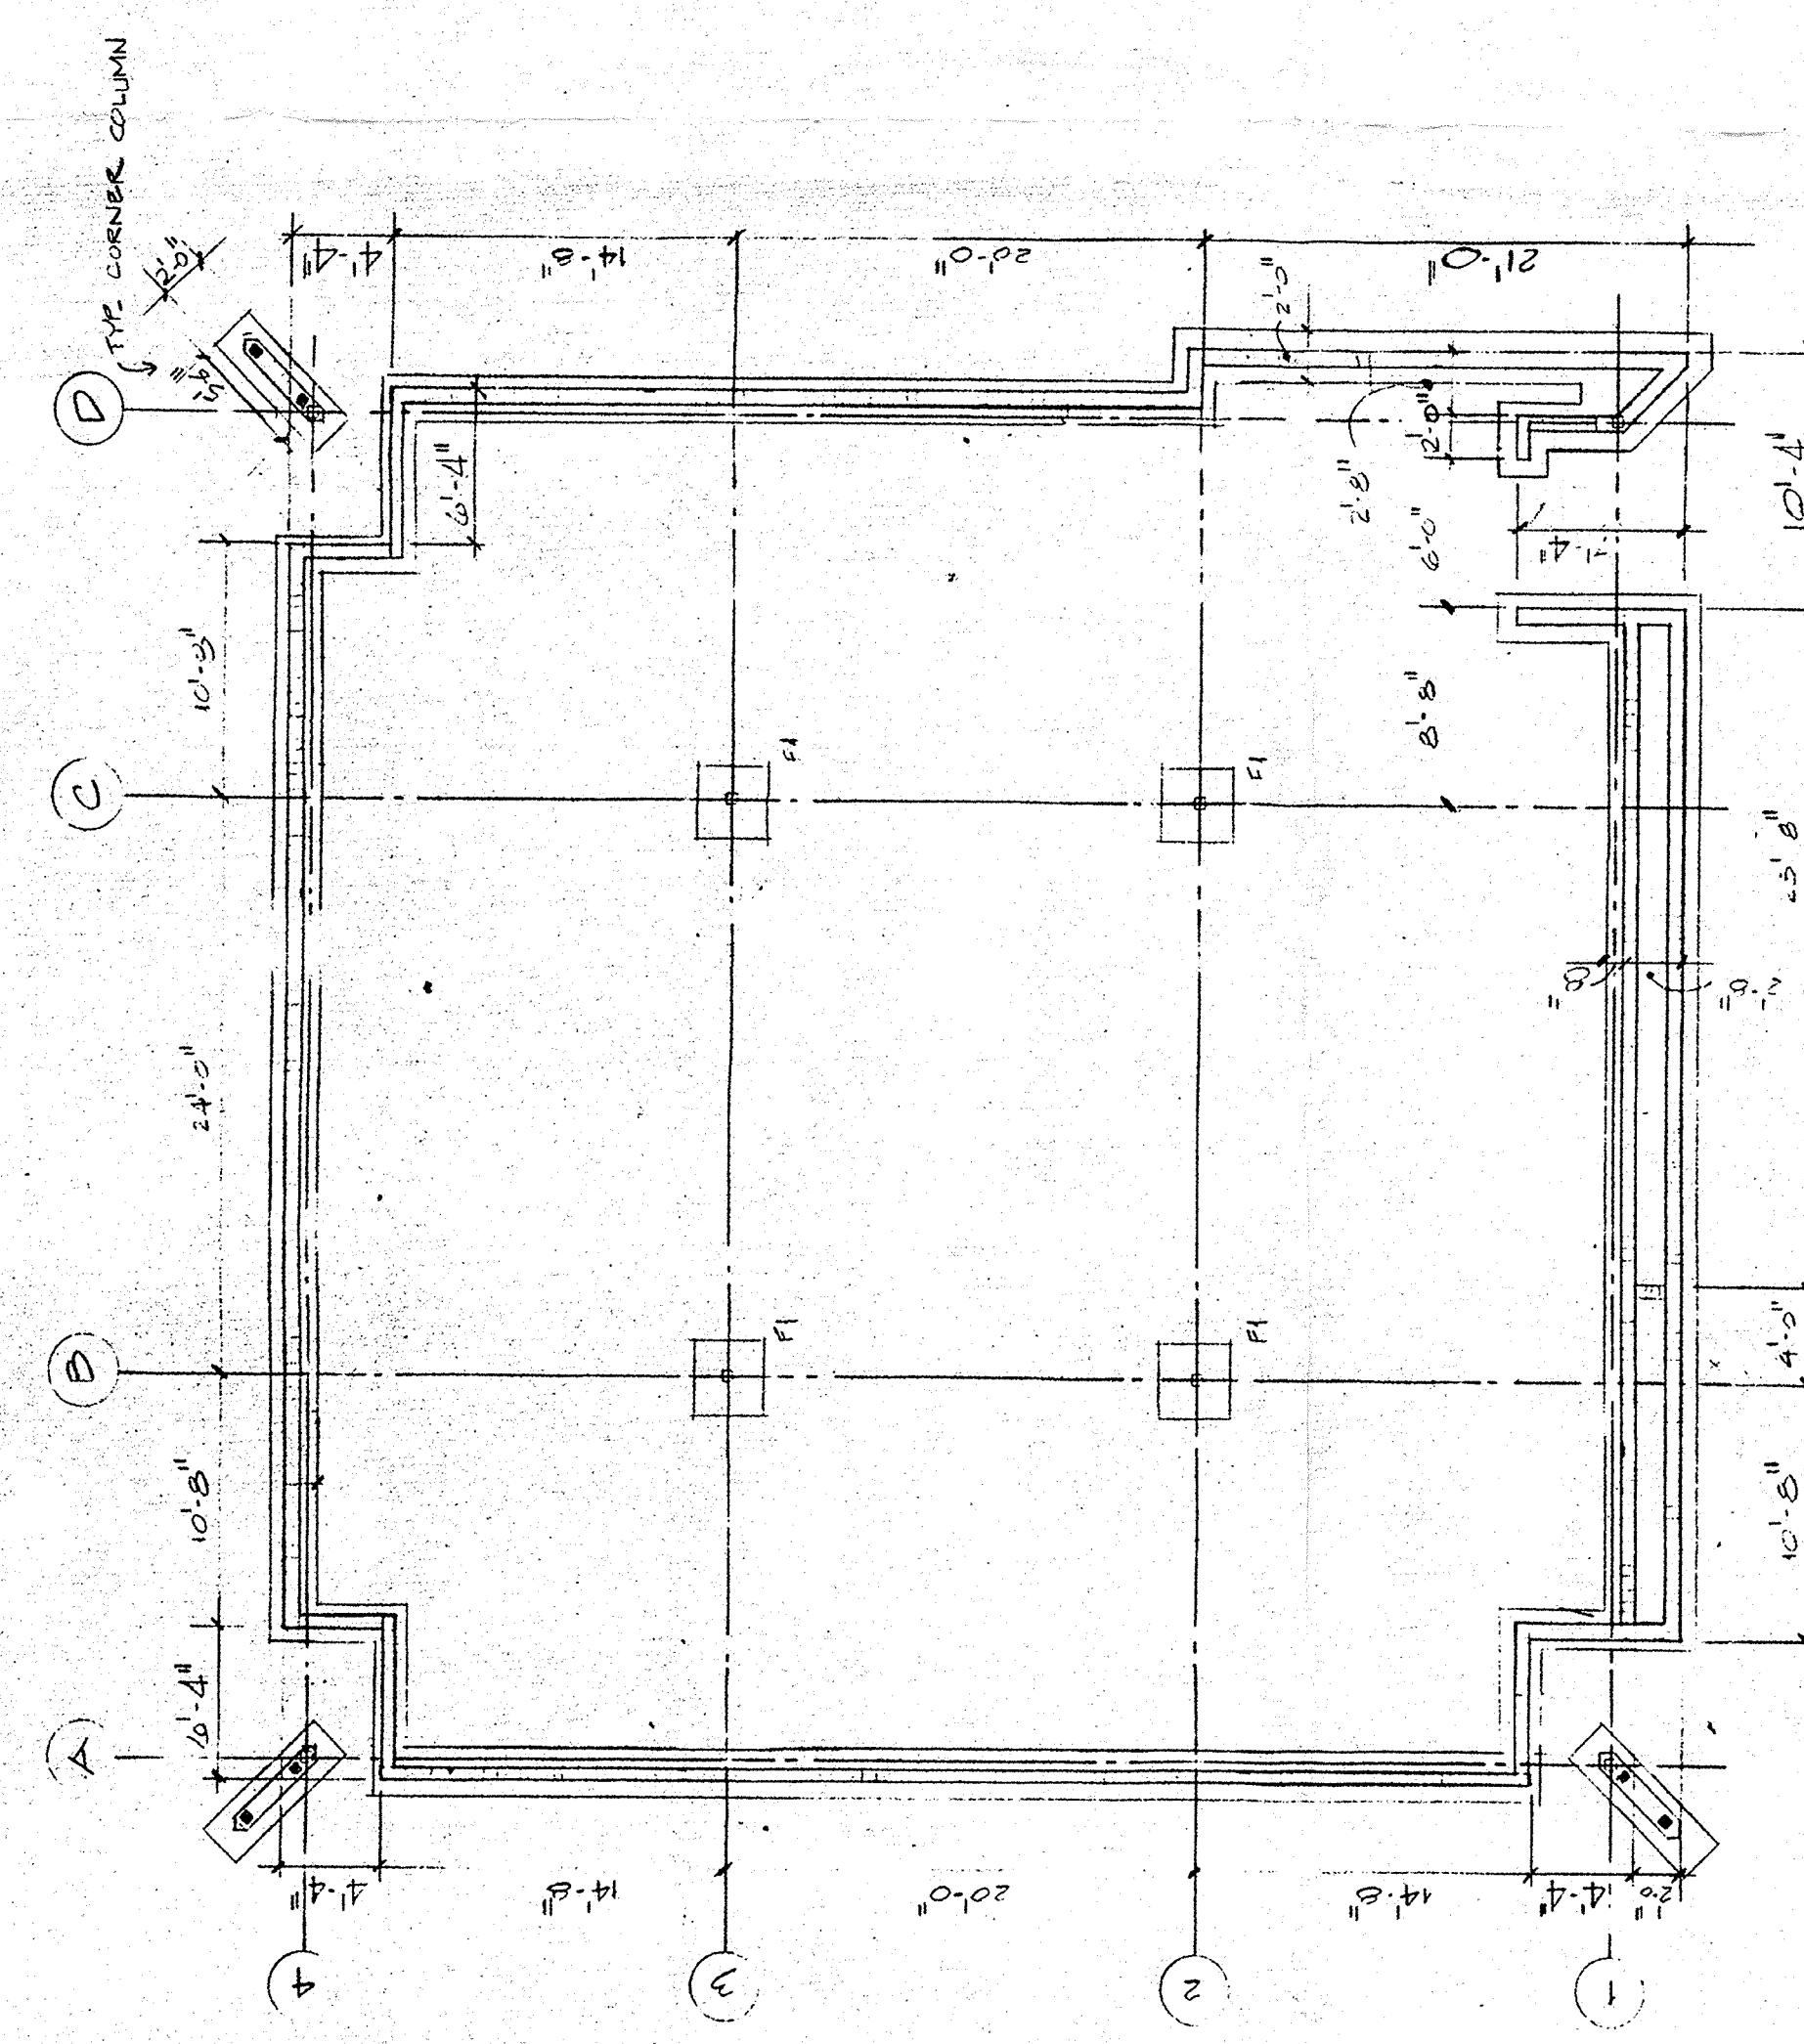

SITE PLAN
 1" = 20'

FLOOR PLAN

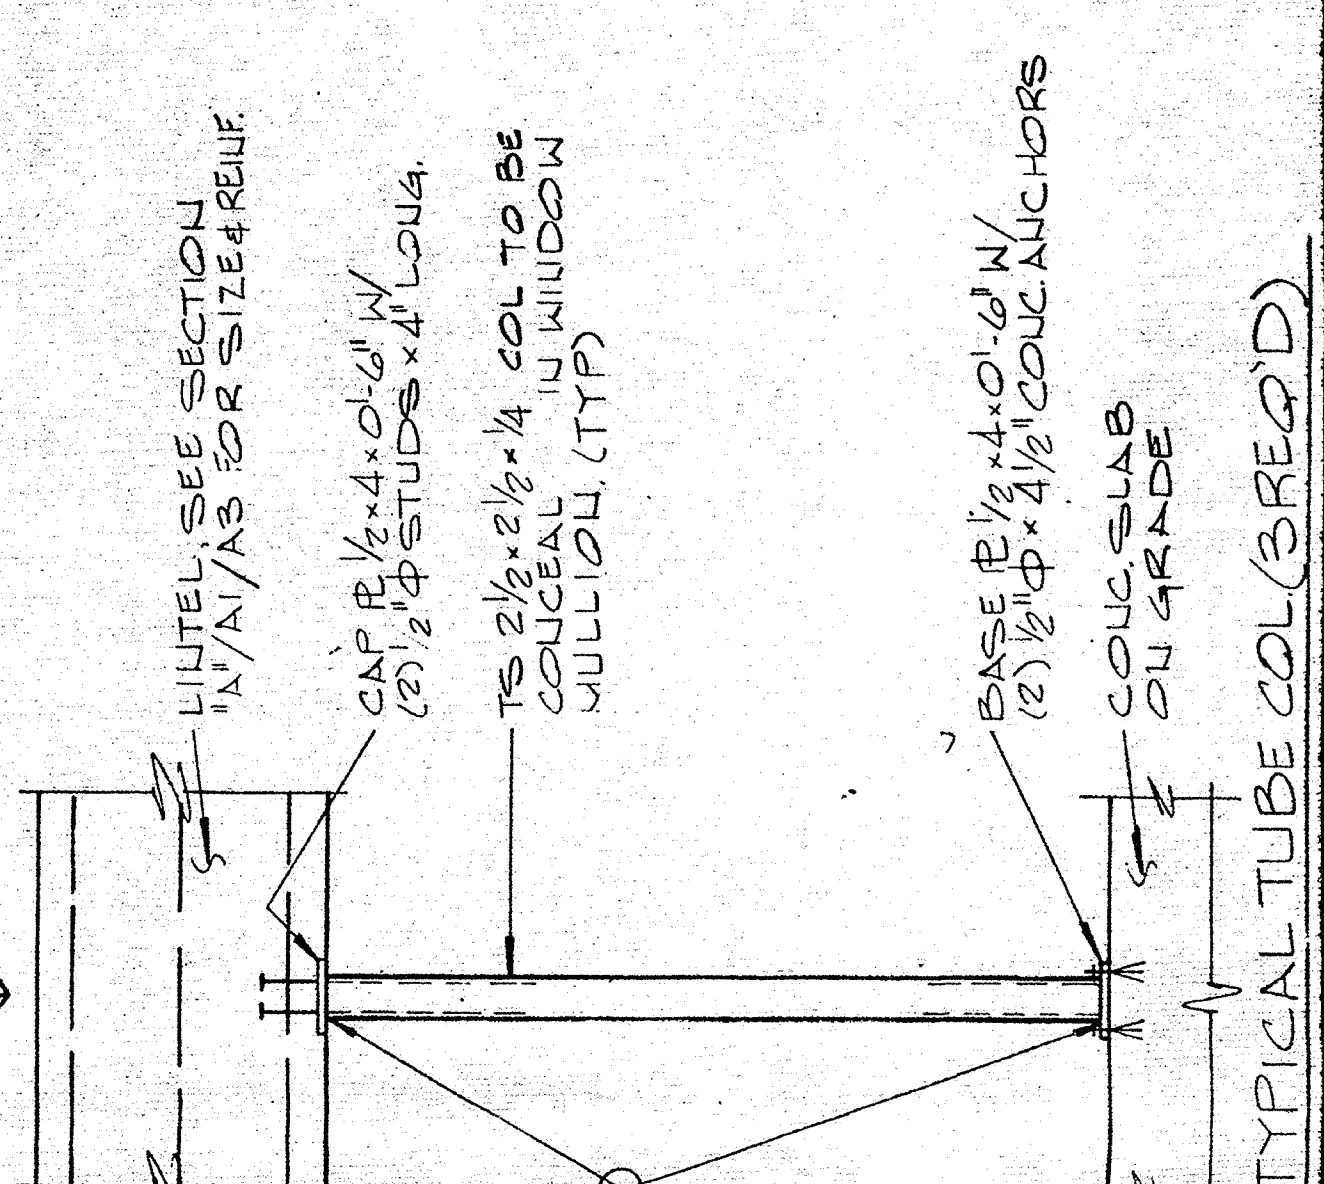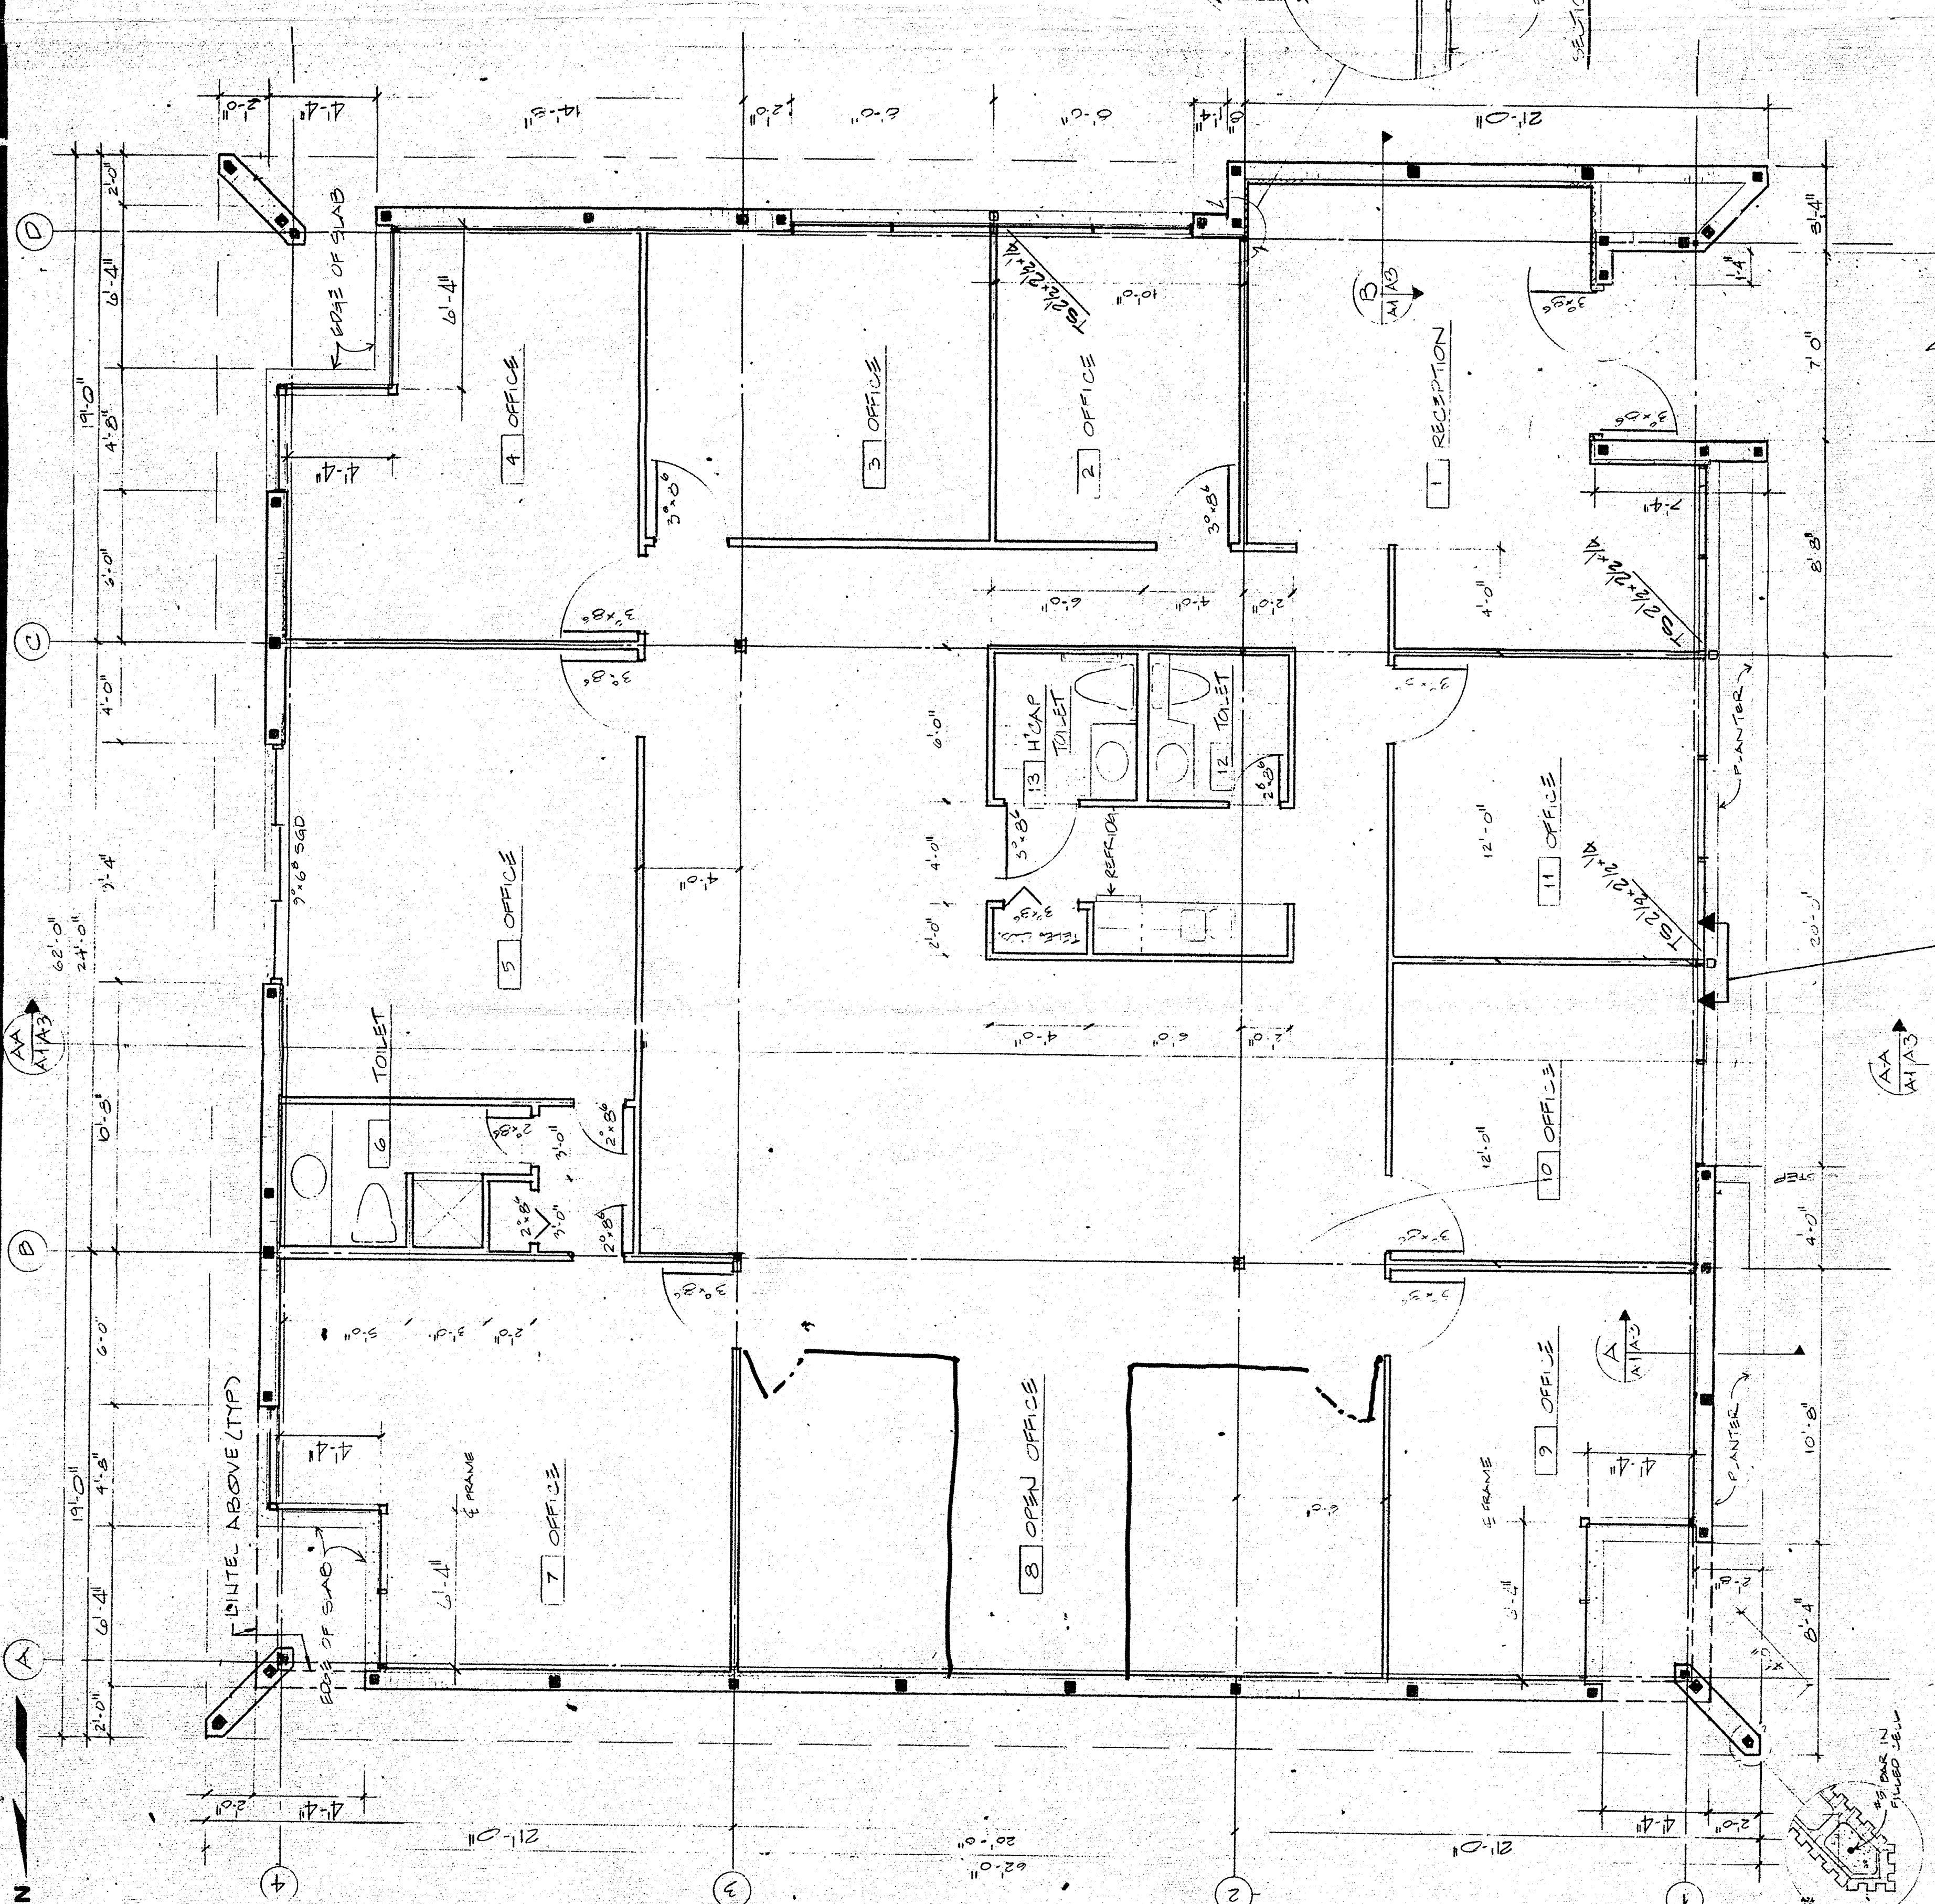

TYPICAL TUBE COL (SPEED)