

INTERIOR TENANT BUILDOUT

EASTCOAST BELIEVERS CHURCH

555 E. SR 436, SUITE 1001

CASSELBERRY, FLORIDA

ARCHITECT

EDWARD L. THOMAS, INC. AIA

1401 EDGEWATER DR., ORLANDO, FL. 32804 PH: (407) 425-4820 FAX: (407) 425-0028

PLUMBING & MECHANICAL ENGINEER

EIERMANN ENGINEERING, INC.

1015 WEBSTER AVE., ORLANDO, FL. 32804 PH: (407) 296-6991 FAX: (407) 296-7420


ELECTRICAL ENGINEER

ALERS ENGINEERING GROUP, LLC

1295 PIMA POINT, OVIEDO, FL. 32765 PH: (407) 681-3935 FAX: (407) 681-3936

DRAWING INDEX


- CS COVER SHEET, DRAWING INDEX, SITE PLAN
- LS-1 LIFE SAFETY PLAN, CODE & U.L. DATA
- A-1 FLOOR PLAN, SCHEDULES, DETAILS
- A-2 REFLECTED CEILING PLAN
- M-1 H.V.A.C. PLAN, NOTES & EQUIPMENT SCHEDULES
- P-1 PLUMBING FLOOR PLAN, RISER, & FIXTURE SCHEDULE
- EC ELECTRIC LEGEND, RISER DIAGRAM, PANEL SCHEDULES
- E-1 LIGHTING, POWER, AND SYSTEMS PLAN

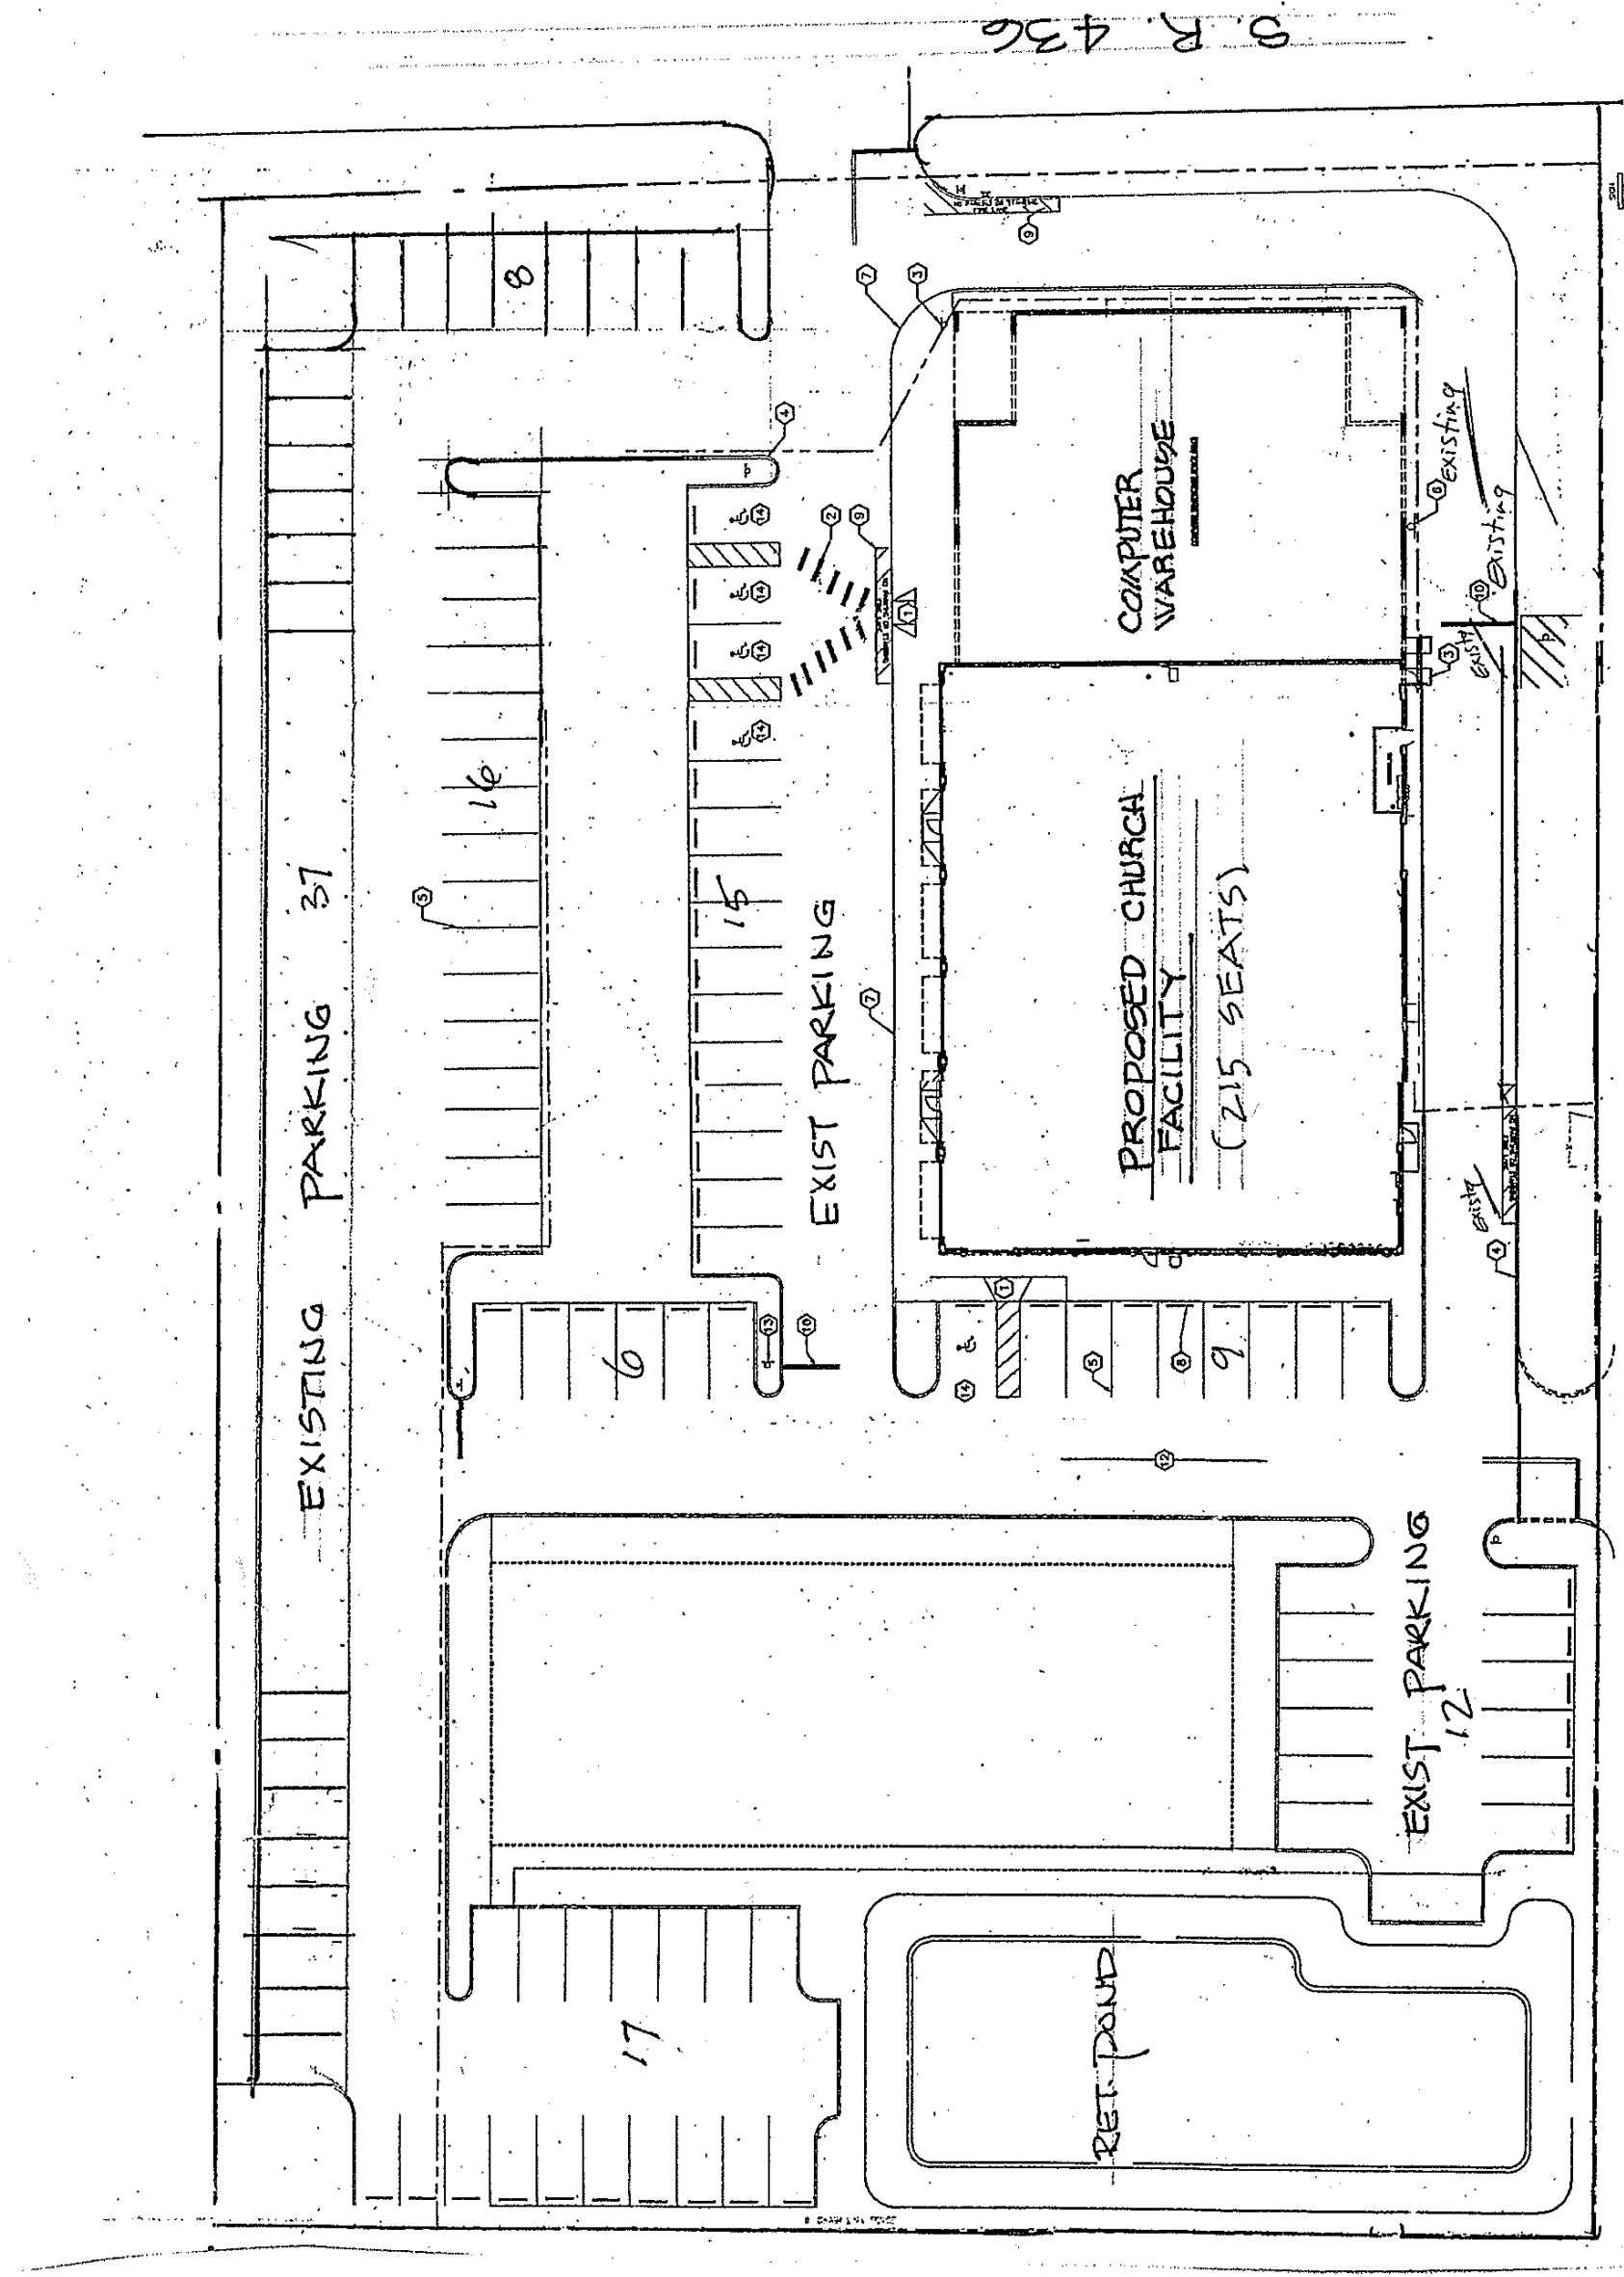

SITE PLAN

SCALE: 1" = 40'
 H.C. PARKING = 6 SPACES
 TOTAL PARKING = 120 SPACES
 NOTE: ALL INDICATED SITE FEATURES ARE EXISTING TO REMAIN

LEGAL DESCRIPTION
 LEG SEC 20 TWP 21S RGE 30E BEG 935 FT S 47 DEG 12 MIN 42 SEC E OF S RW ST RD 436 + N LINE OF SEC RUN S 47 DEG 12 MIN 42 SEC E 300 FT S 42 DEG 47 MIN 18 SEC W 436.5 FT N 47 DEG 12 MIN 42 SEC W 300 FT N 42 DEG 47 MIN 18 SEC E 436.5 FT TO BEG.

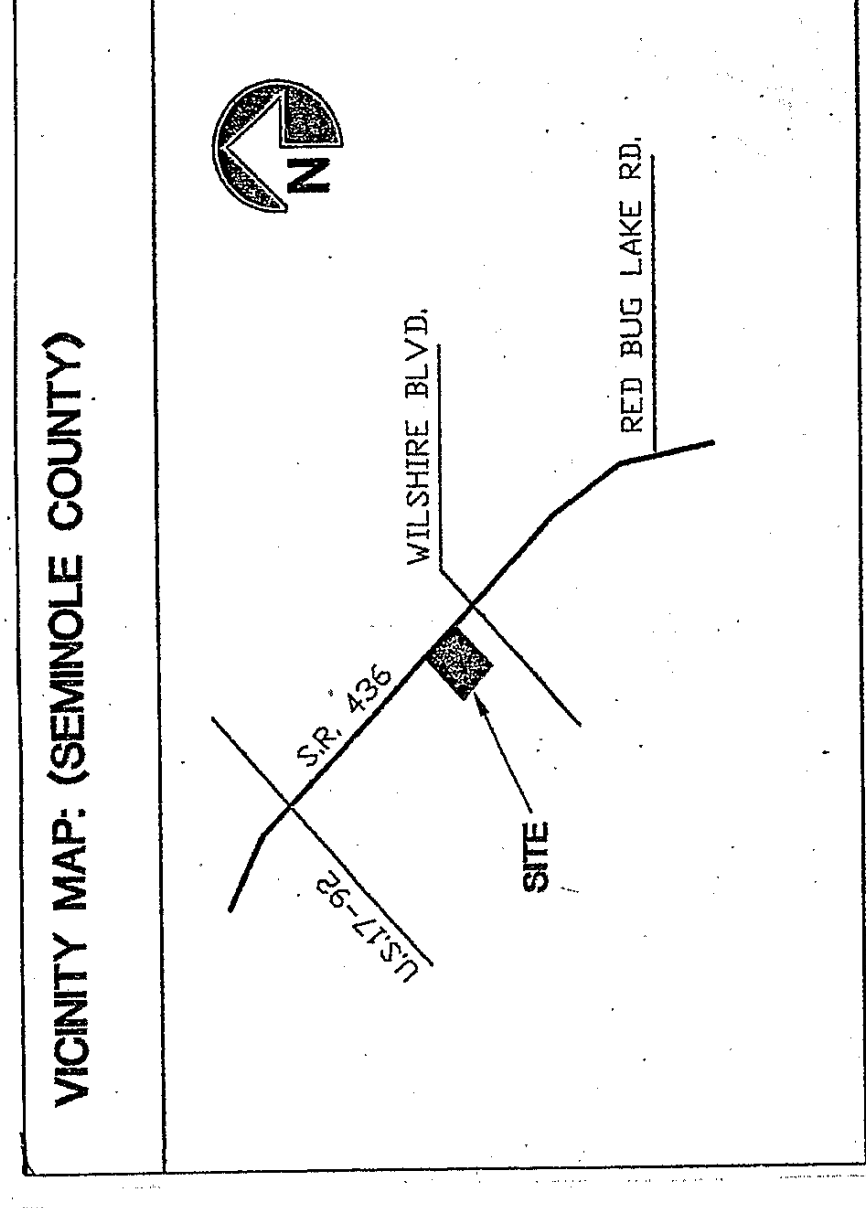

SITE VICINITY MAP

NO SCALE