

CEILING FINISH LEGEND

- ⊙ 9'-0" CEILING ELEVATION AFF. 9'-0" UNLESS OTHERWISE NOTED
- ACT-1 24 X 24 X 3/4 WHITE ANGLED TEGULAR W/5/16 EXPOSED GRID
- GB-1 1/2" GYP BD SOFFIT ON MTL. STUD FRAMING
- LC 6YP BD LIGHT COVE
- STUC OPEN TO STRUCTURE


LEGEND

ALL FLUORESCENT TROFFERS TO BE CONNECTED TO STRUCTURE ABOVE WITH SPLAYED WIRES FROM TWO OPPOSITE CORNERS

- [Symbol] 2' X 4' FLUORESCENT LIGHT FIXTURE W/ACRYLIC LENS
- [Symbol] 2' X 4' FLUORESCENT W/D DEEP CELL PARABOLIC
- [Symbol] 2' X 2' FLUORESCENT W/D DEEP CELL PARABOLIC
- [Symbol] 1' X 1' RECESSED HLD
- [Symbol] EXTERIOR SURFACE MTD HID
- [Symbol] 1' X 4' LIGHT FIXTURE
- [Symbol] UNDER CABINET LIGHTING
- [Symbol] RECESSED CAN LIGHT, DIAMETER INDICATED
- [Symbol] RECESSED CAN LIGHT WALL WASHER
- [Symbol] WALL SURFACE MTD FIXTURE
- [Symbol] DECORATIVE PENDANT FIXTURE 1
- [Symbol] DECORATIVE PENDANT FIXTURE 2
- [Symbol] TRACK LIGHTING
- [Symbol] EXHAUST FAN
- [Symbol] HVAC SUPPLIES
- [Symbol] HVAC RETURN AIR
- [Symbol] 2X2 LAY IN ACOUSTICAL CEILING
- [Symbol] FRAME WALL 1/2" GYP. BD ASSY TO BOTTOM OF SUB CLR AT TRUSSES PROVIDE SOUND BATTIS LOW WALL-HEIGHT @ 7'-6"
- [Symbol] ACCESS PANEL
- [Symbol] EXIT SIGN
- [Symbol] THERMOSTAT, NO. INDICATES ZONE
- [Symbol] PROVIDE POWER AND BACKING FOR ILLUMINATED OPEN / CLOSE SIGN BY OTHERS
- [Symbol] PROVIDE POWER AND BACKING FOR ILLUMINATED SIGN BY OTHERS

KEYED NOTES

- 1 COORDINATE DECORATIVE PENDANT LOCATIONS W/ GREETER STATION MILLWORK
- 2 SEE SHEET A.08 FOR SOFFIT DIMENSIONS
- 3 CENTER LIGHTS OVER DEAL PLATE OPENING

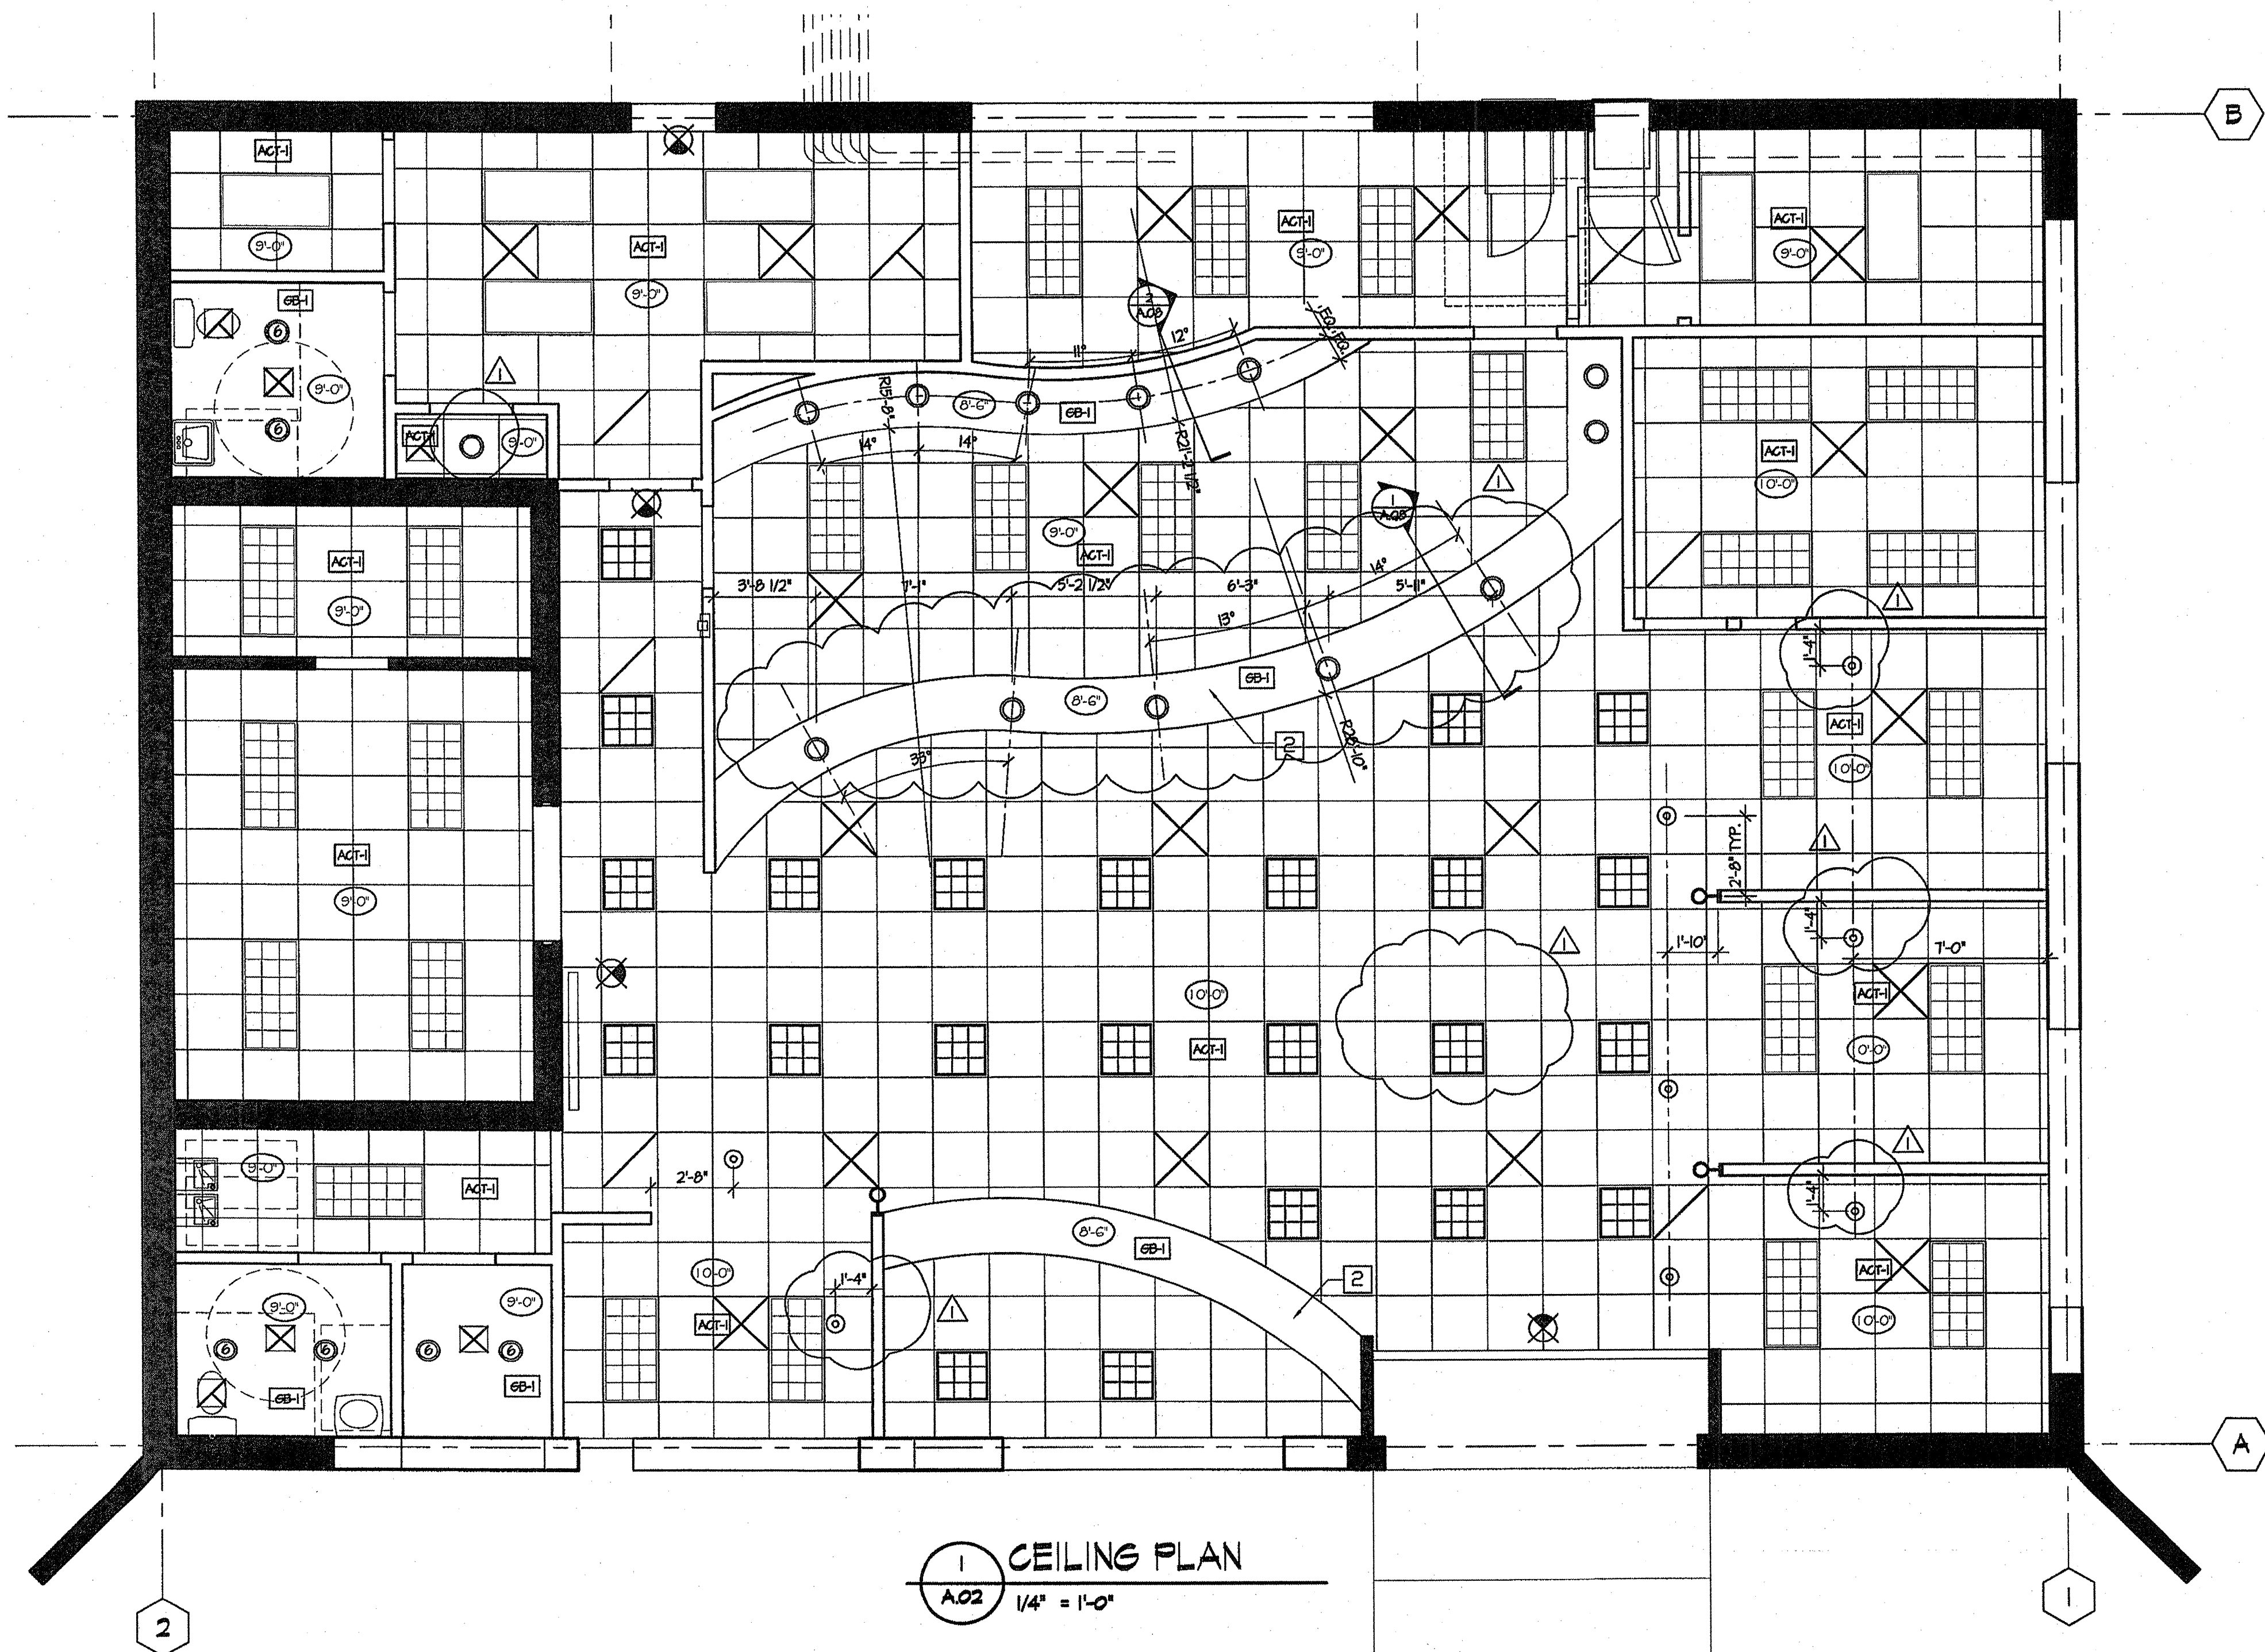


1 CEILING PLAN
A.02 1/4" = 1'-0"

KDA Holdings
Building on Ideas
350 Franklin Road
Marietta, GA 30067
Phone: 770.421.1532
Fax: 770.422.8285

Warner
Summers
Ditzel
Benefield
Ward & Associates
ARCHITECTURE & INTERIOR DESIGN
67 PEACHTREE PARK DRIVE ATLANTA, GA 30309
660 53-0755 FAX 660 25-0811

WSDBW NO. 06091

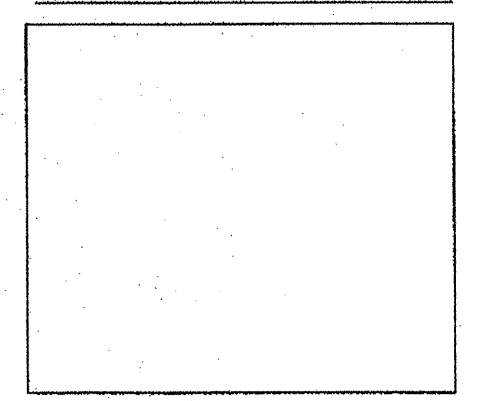

FAIRWINDS
CREDIT UNION
Sanford Branch

ISSUE:		
Date	Rev.	Description
3/30/07		C.D. PRESENTATION
5/25/07		Plan Coordination

KDA
Project Number: 27-0003
Drawn By: gar
Checked By: csw
Scale:

REFLECTED CEILING PLAN
A.02