




F:\PROJECT\92211\HVAC\ANS\MECHANICAL\WISC\MEZZ MEZZ Thu Dec 8 11:00:29 1994 x E.R.U x

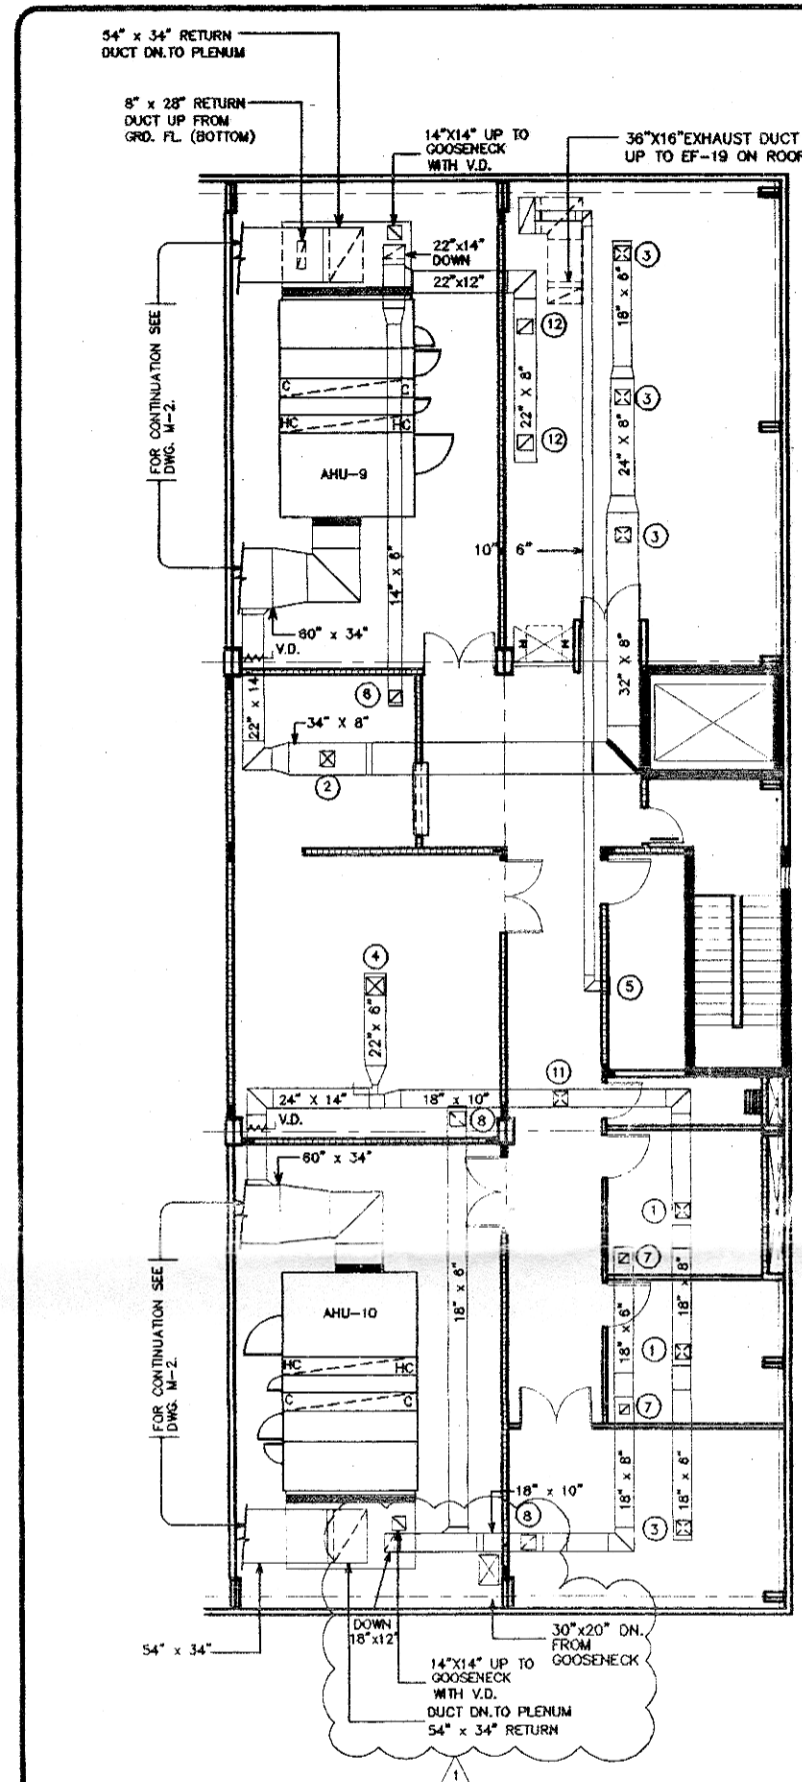


MEZZANINE ABOVE 2ND. FLOOR PLAN
SCALE: 1/8" = 1' - 0"

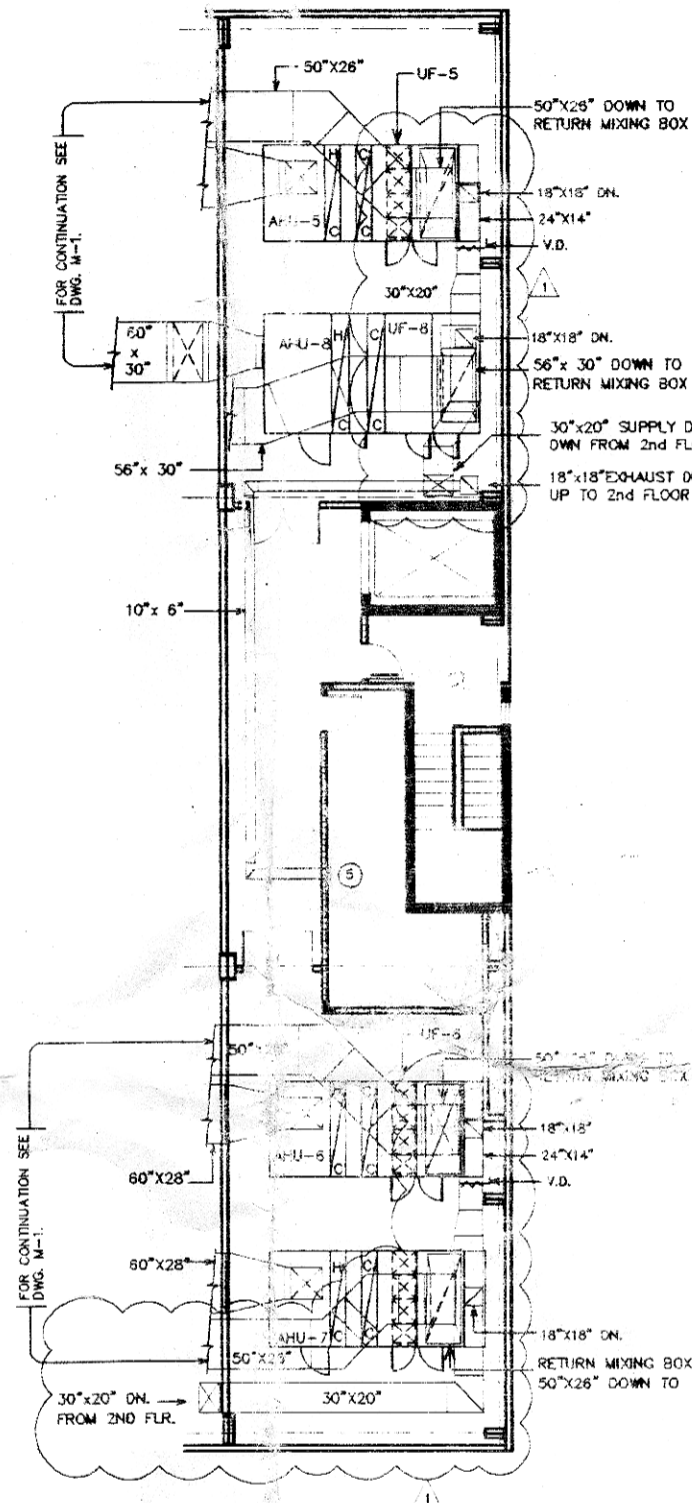

MEZZANINE ABOVE GRD. FLOOR PLAN
SCALE: 1/8" = 1' - 0"

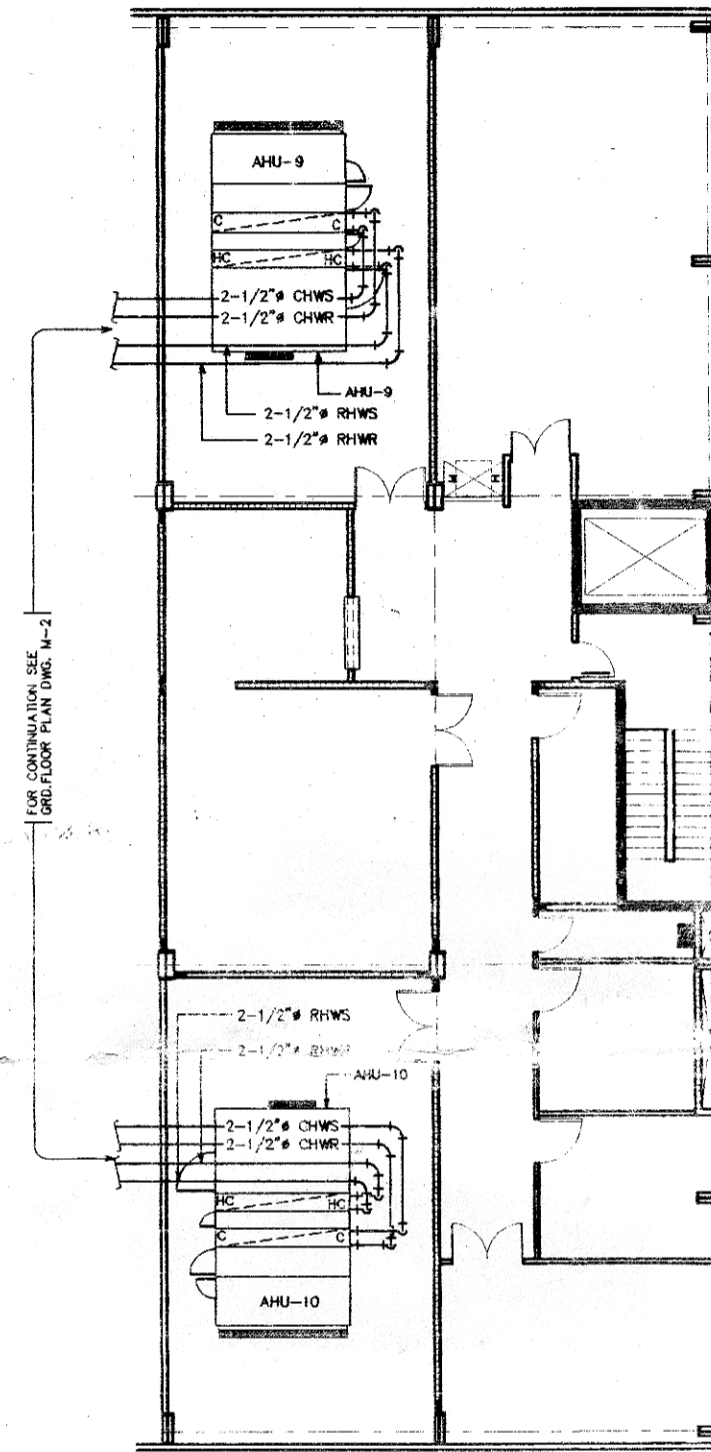

MEZZANINE ABOVE 2ND. FLOOR PLAN
SCALE: 1/8" = 1' - 0"

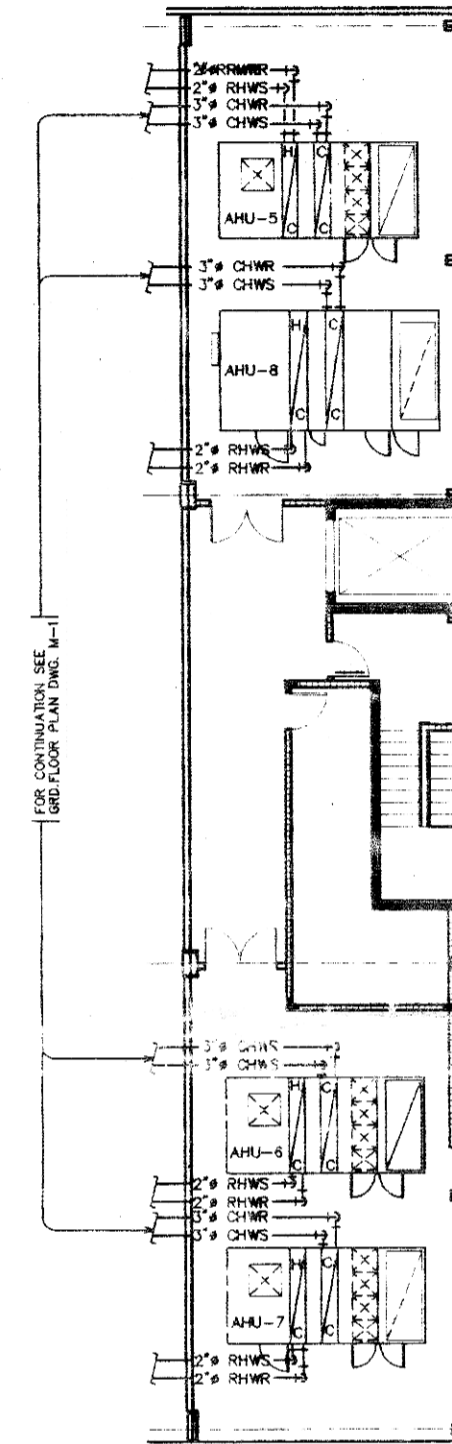


MEZZANINE ABOVE GRD. FLOOR PLAN
SCALE: 1/8" = 1' - 0"

PERFORMANCE OF DIFFUSERS AND REGISTERS							
NO.	MANUFACTURER	MODEL	SIZE IN.	C.F.M.	VOLUME CONTROL TYPE	QTY.	REMARKS
1	METALAIRE	5000-M1	12"x12"	250	O.B.D. INC.	2	4 WAY SUPPLY
2	METALAIRE	5000-M1	15"x15"	300	O.B.D. INC.	1	4 WAY SUPPLY
3	METALAIRE	5000-M1	15"x15"	500	O.B.D. INC.	4	4 WAY SUPPLY
4	METALAIRE	5000-M1	18"x18"	600	O.B.D. INC.	1	4 WAY SUPPLY
5	METALAIRE	R H D	10"x4"	150	O.B.D. INC.	2	EXHAUST
6	METALAIRE	R H D	15"x15"	300	O.B.D. INC.	1	RETURN
7	METALAIRE	R H D	10"x10"	250	O.B.D. INC.	2	RETURN
8	METALAIRE	R H D	14"x14"	500	O.B.D. INC.	2	RETURN
9	RUSSK	EL-31	36"x36"	1,500		4	OUTSIDE AIR
10	RUSSK	EL-31	36"x36"	1,500		2	OUTSIDE AIR
11	METALAIRE	5000-M1	12"x12"	200	O.B.D. INC.	1	2 WAY SUPPLY
12	METALAIRE	RHD	18"x18"	750	O.B.D. INC.	2	RETURN

A/C Ducts, CHW & RHW Piping Layout - Mezzanines

Project Number:	
Drawing Number:	
Revisions	
No.	Date
1	08.23.94
Changes/New Design	
No.	Date
CAD Data	
Drawn by:	
Checked by:	
Approved:	

Working Drawings for the Expansion of
Plant for FERRERO, Inc.
 Caguas, Puerto Rico

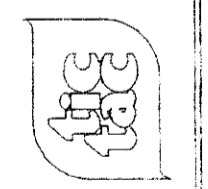

Scale: 1/8" = 1' - 0"



Page: of
 M-3
 CHARLES NEIDER ENTERPRISES